



'MODERN'
CLADDING
THEME SHOWN



DRAWING LIST

SHEET NUMBER	SHEET NAME	CURRENT REVISION
A000	TITLE PAGE	A
A101	FLOOR PLAN	A
A102	ELEVATIONS 1 OF 2	A
A103	ELEVATIONS 2 OF 2	A
A104	SECTION & INTERNAL 3D VIEWS	A
A105	KITCHEN JOINERY DETAILS	A
A106	SCHEDULES	A

ORANA

10.0 x 6.0m 2 BEDROOM DWELLING with DECK

'THE AIRLIE'
ORANA

14729 Spring Avenue,
Santa Fe Springs, CA, 90670
E: hello@oranausa.com
P: 888 256 6416

WIND REGION:			 NORTH
TERRAIN CATEGORY:			
IMPORTANCE LEVEL:			
SHIELDING FACTOR:			
BUILDING CLASS:		1a	
FLOOR LOADS	DISTRIBUTED (kPa):	1.5	
	CONCENTRATED (kN):	1.2	
CLIMATE ZONE:			

FLOOR LOADS CALCULATED FROM AS1170.1 - 2002. WIND SPEED CALCULATED FROM AS1170.2 - 2021. BUILDING CLASS, IMPORTANCE LEVEL, PROBABILITY OF EXCEEDANCE, WIND REGION, TERRAIN CATEGORY, TOPOGRAPHIC CLASIFICATION, SHIELDING FACTOR, CLIMATE ZONE & NORTH POINT ARE ASSUMED UNLESS OTHERWISE ADVISED BY CLIENT.

ELECTRICAL SYMBOL LEGEND

	ELECTRICAL SWITCHBOARD		GPO, 1 x 10AMP
	ELECTRICAL POINT OF ENTRY		GPO, 2 x 10AMP
	LIGHT SWITCH, SINGLE		20AMP AC ISOLATION SWITCH
	LIGHT SWITCH, TWO GANG		LED DOWNLIGHT
	LIGHT SWITCH, THREE GANG		240V SMOKE ALARM
	FAN/LIGHT SWITCH		

SET OUTS, LEVELS AND CRITICAL DIMENSIONS TO BE CONFIRMED ON SITE PRIOR TO FABRICATION
DO NOT SCALE FROM THIS DRAWING, USE FIGURED DIMENSIONS
ALL CONSTRUCTION TO COMPLY WITH NATIONAL CONSTRUCTION CODE OF AUSTRALIA (NCC) AND RELEVANT AUSTRALIAN STANDARDS
ALL DESIGNS © ORANA, 2026

REVISION SCHEDULE

REV	DESCRIPTION	DATE	BY
A	ISSUED FOR REVIEW	28.03.26	DM

DRAWING STATUS

ISSUED FOR REVIEW

ORANA

14729 Spring Avenue,
Santa Fe Springs, CA, 90670
E: hello@oranausa.com
P: 888 256 6416

BUILDING NAME

'THE AIRLIE'

DESCRIPTION

10.0 x 6.0m 2 BEDROOM
DWELLING with DECK

CLIENT

ORANA

SHEET TITLE

FLOOR PLAN

DRAWING NUMBER


A101


REVISION

A

SCALE AT A3
1 : 50


29/03/2026 12:35:32 AM

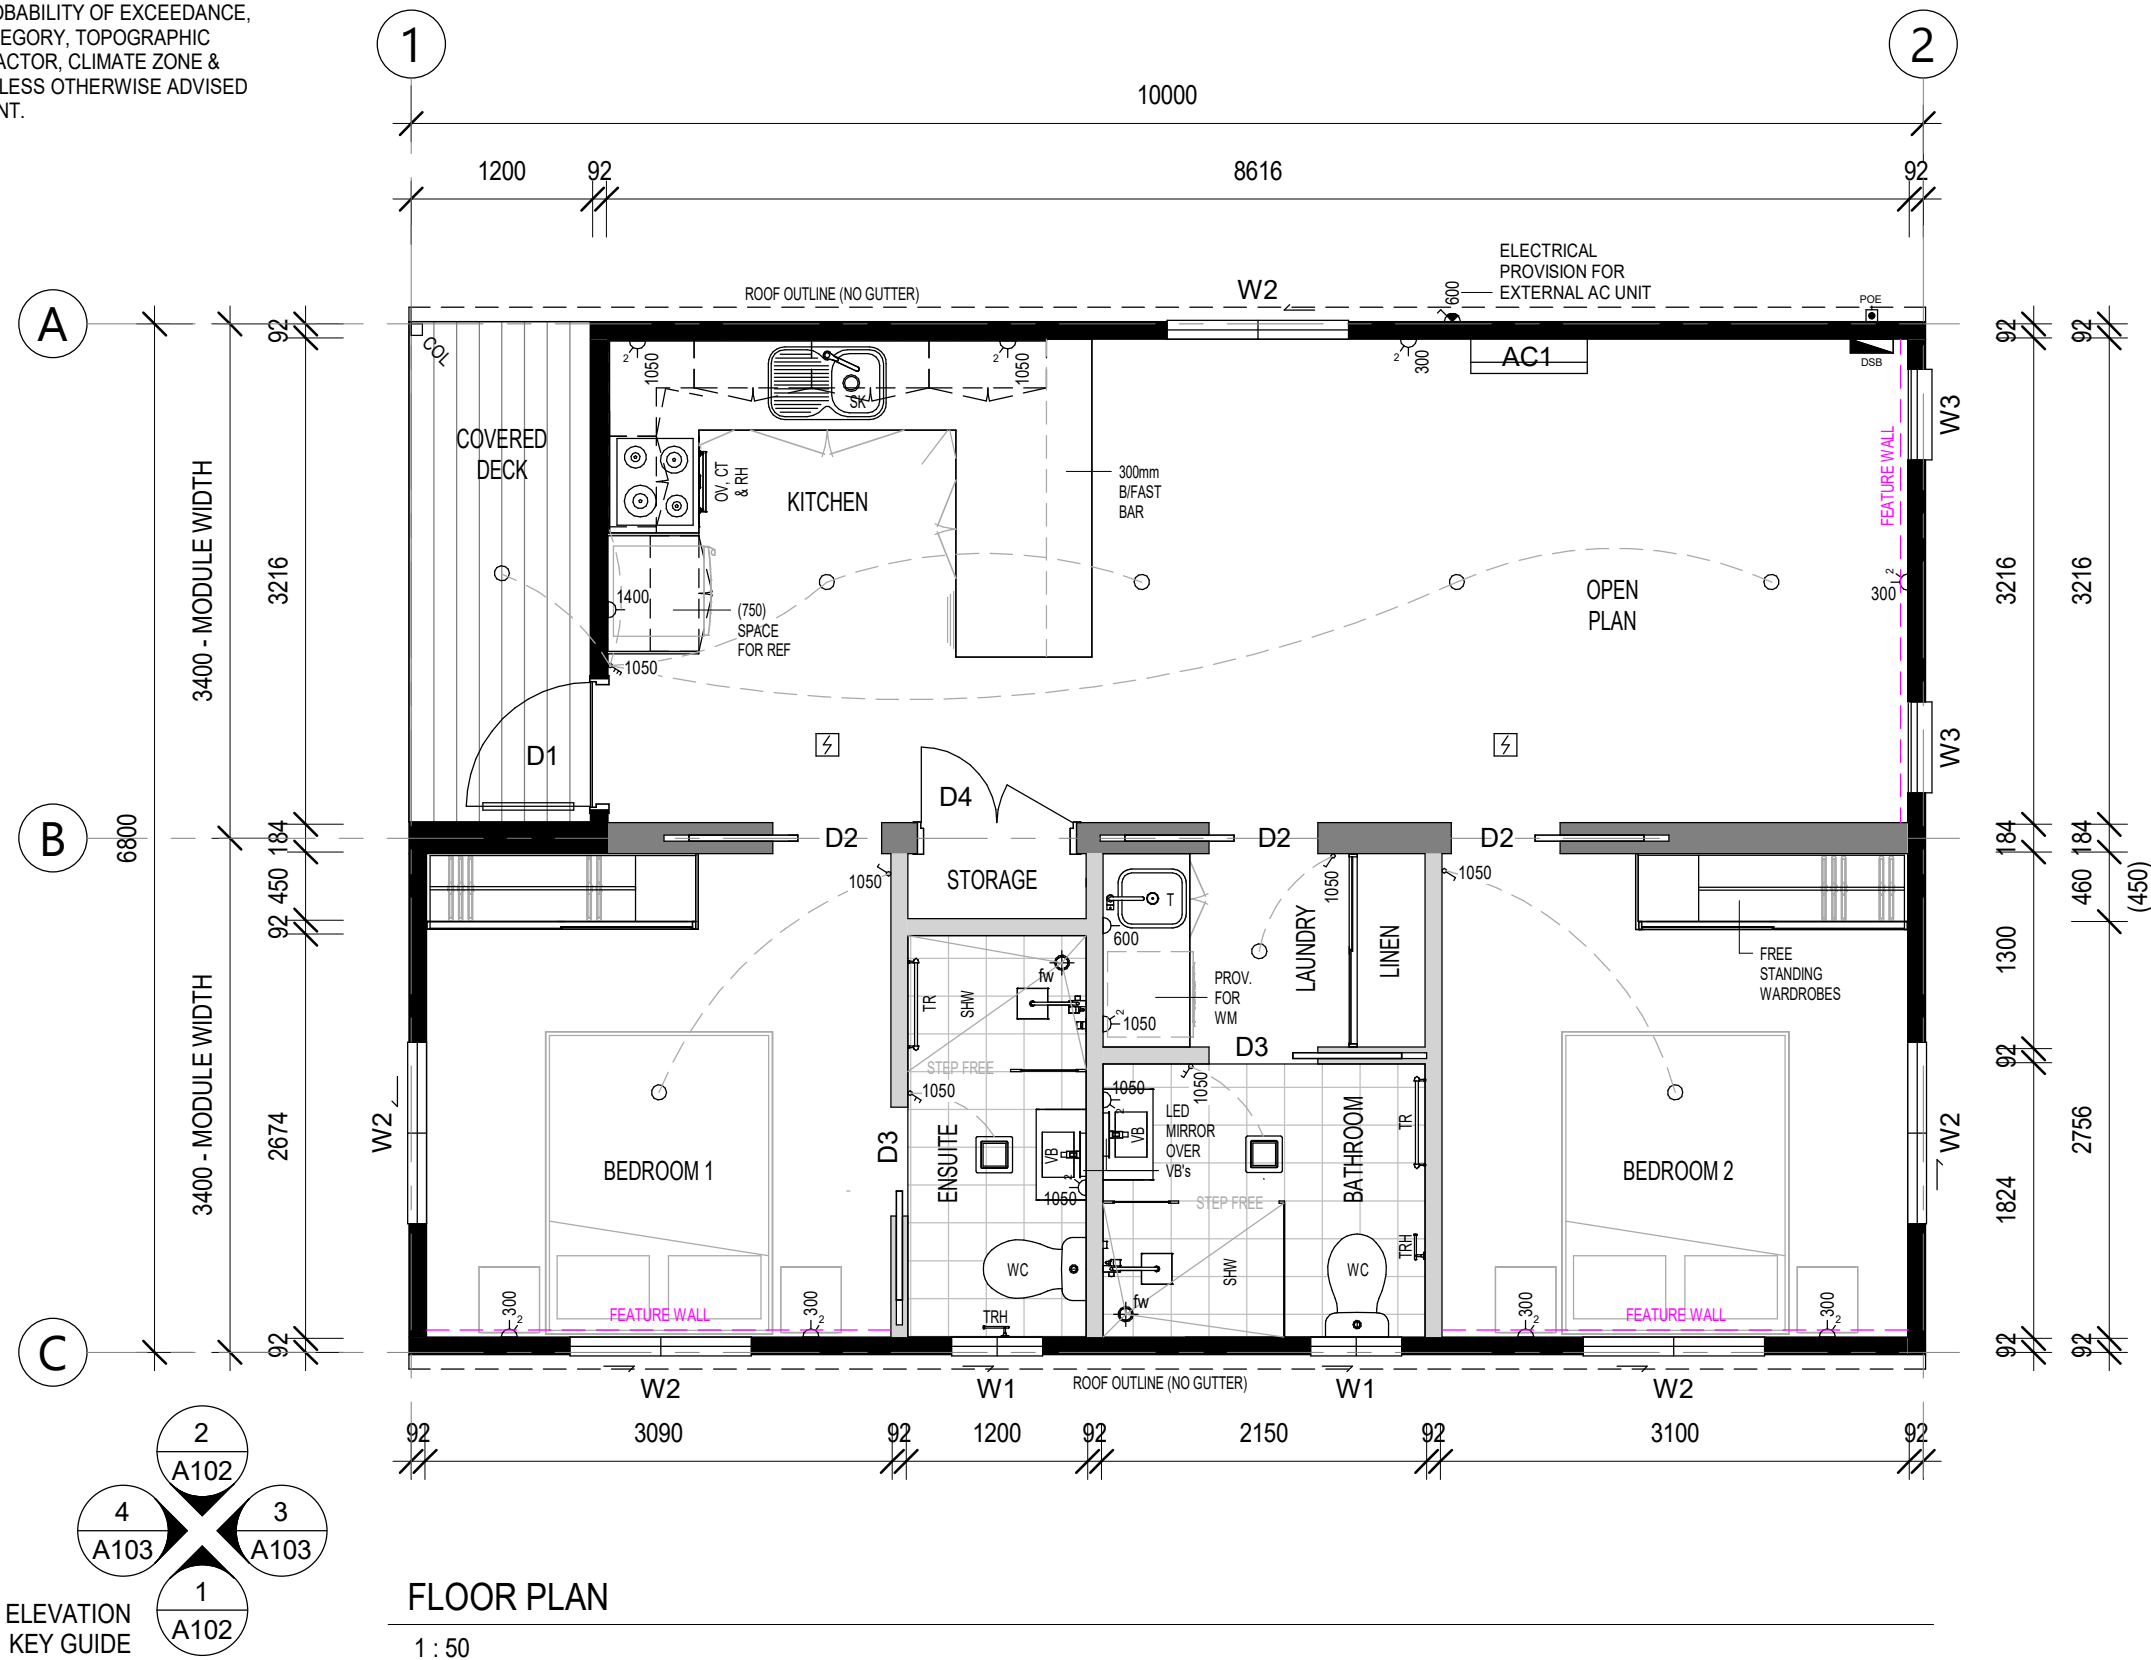

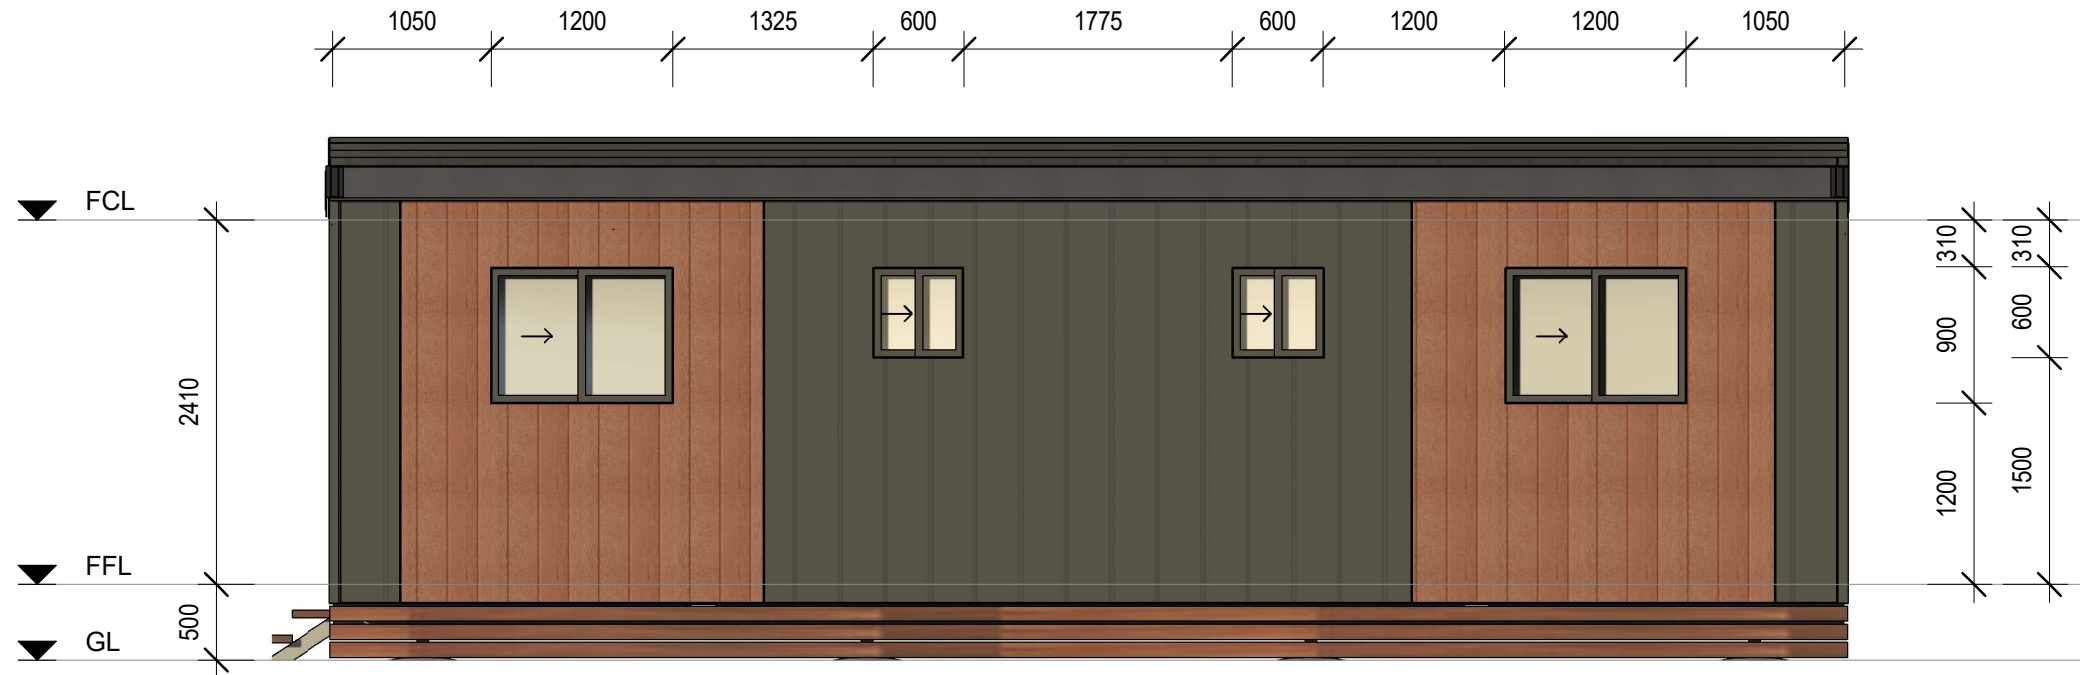

FRONT ELEVATION (1)

1 : 50

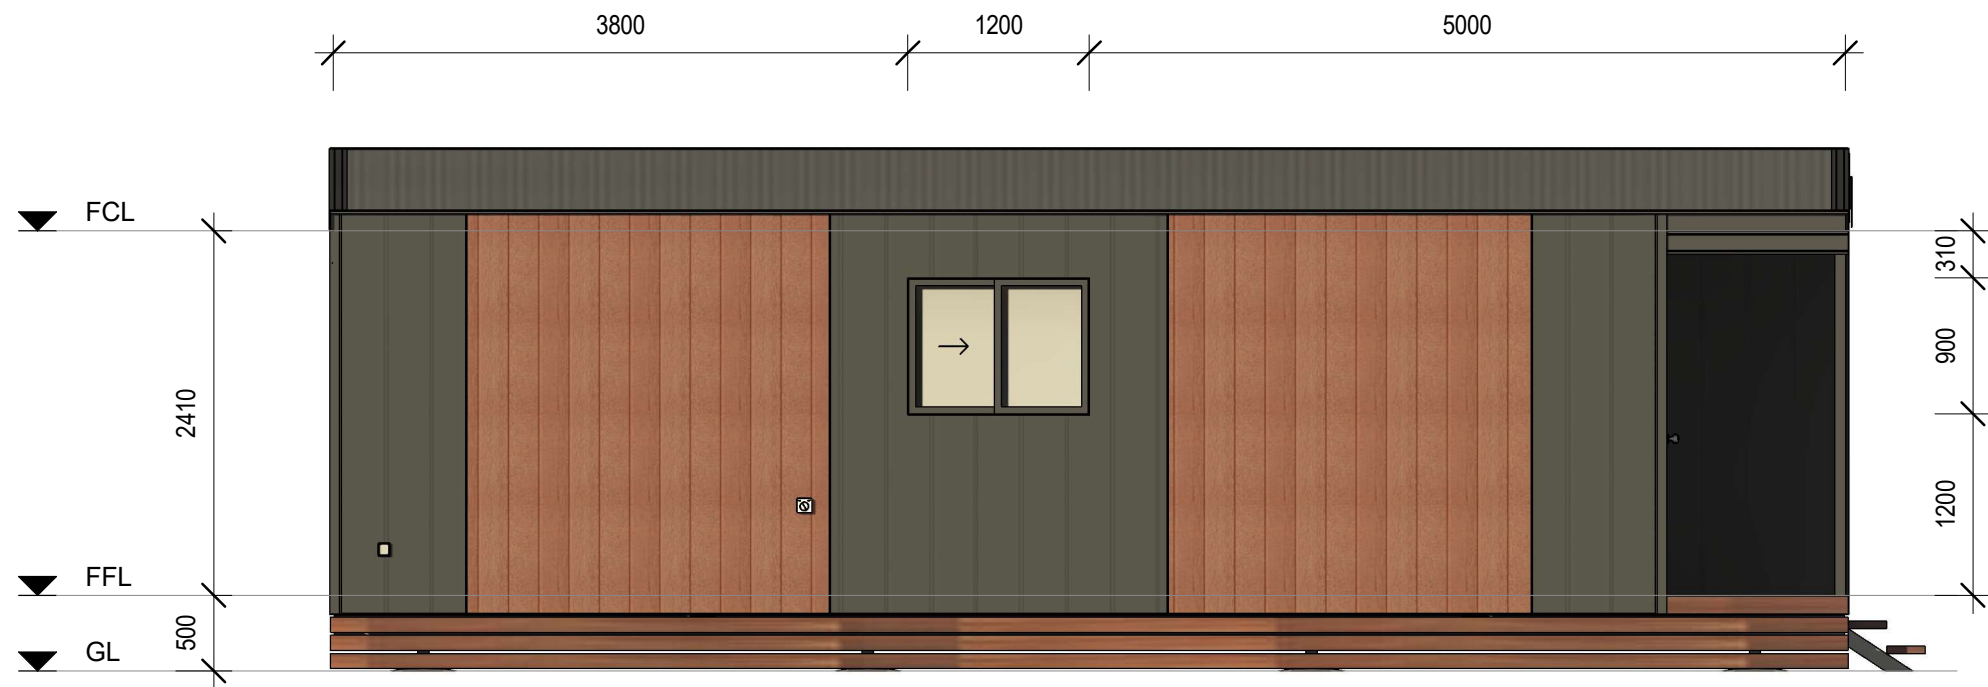

REAR ELEVATION (2)

1 : 50

SET OUTS, LEVELS AND CRITICAL DIMENSIONS TO BE
CONFIRMED ON SITE PRIOR TO FABRICATION
DO NOT SCALE FROM THIS DRAWING, USE FIGURED
DIMENSIONS
ALL CONSTRUCTION TO COMPLY WITH NATIONAL
CONSTRUCTION CODE OF AUSTRALIA (NCC) AND
RELEVANT AUSTRALIAN STANDARDS
ALL DESIGNS © ORANA, 2026

REVISION SCHEDULE			
REV	DESCRIPTION	DATE	BY
A	ISSUED FOR REVIEW	28.03.26	DM

DRAWING STATUS

ISSUED FOR
REVIEW

ORANA

14729 Spring Avenue,
Santa Fe Springs, CA, 90670
E: hello@oranausa.com
P: 888 256 6416

BUILDING NAME

'THE AIRLIE'

DESCRIPTION

10.0 x 6.0m 2 BEDROOM
DWELLING with DECK

CLIENT

ORANA

SHEET TITLE

ELEVATIONS 1 OF 2


DRAWING NUMBER

A102

REVISION
A
SCALE AT A3
1 : 50


29/03/2026 12:35:34 AM

SET OUTS, LEVELS AND CRITICAL DIMENSIONS TO BE
CONFIRMED ON SITE PRIOR TO FABRICATION
DO NOT SCALE FROM THIS DRAWING, USE FIGURED
DIMENSIONS
ALL CONSTRUCTION TO COMPLY WITH NATIONAL
CONSTRUCTION CODE OF AUSTRALIA (NCC) AND
RELEVANT AUSTRALIAN STANDARDS
ALL DESIGNS © ORANA, 2026

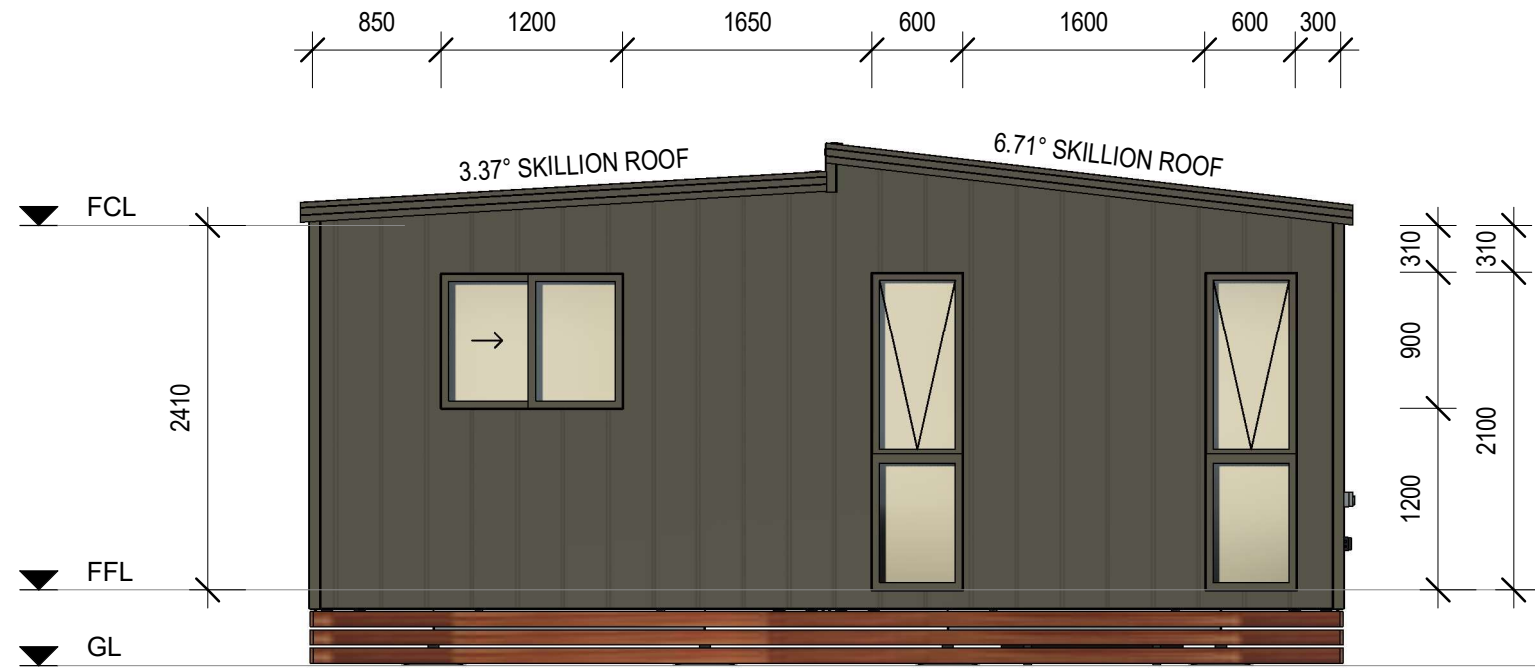

RIGHT ELEVATION (3)

1 : 50

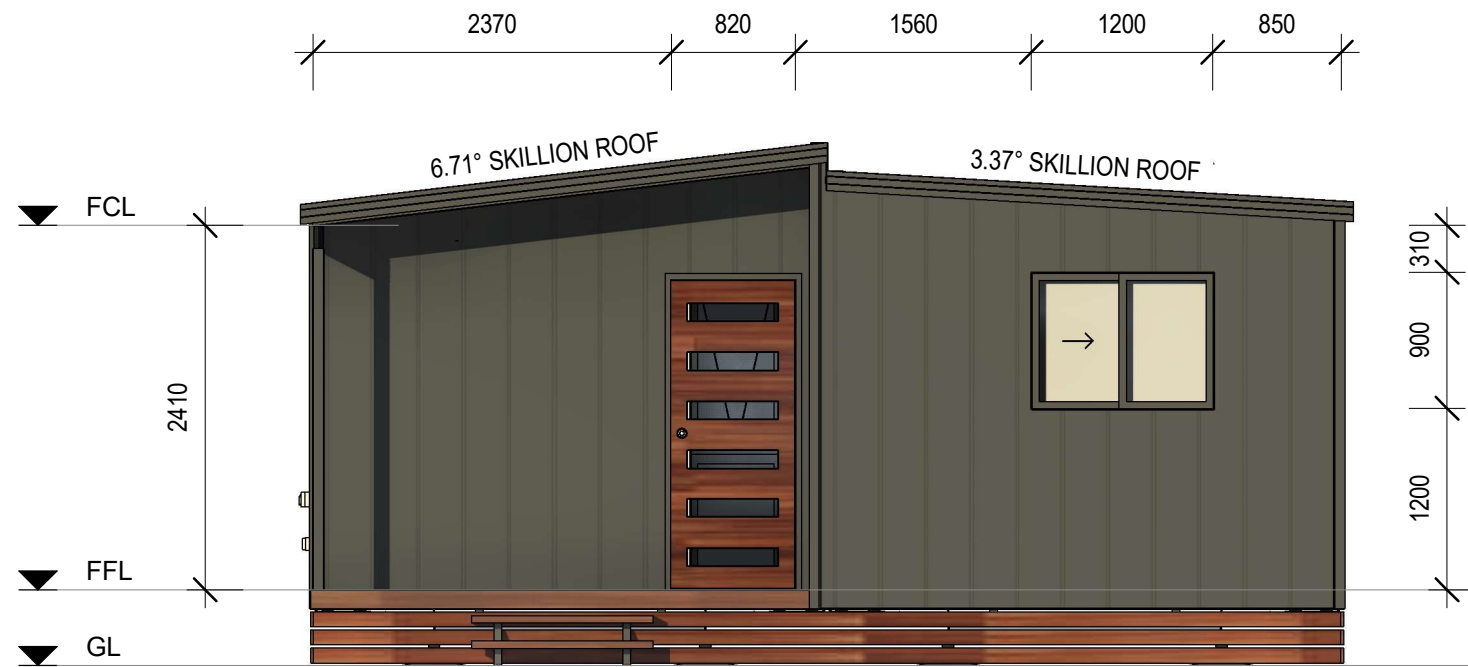

LEFT ELEVATION (4)

1 : 50

REVISION SCHEDULE			
REV	DESCRIPTION	DATE	BY
A	ISSUED FOR REVIEW	28.03.26	DM

DRAWING STATUS

ISSUED FOR
REVIEW

ORANA

14729 Spring Avenue,
Santa Fe Springs, CA, 90670
E: hello@oranausa.com
P: 888 256 6416

BUILDING NAME

'THE AIRLIE'

DESCRIPTION

10.0 x 6.0m 2 BEDROOM
DWELLING with DECK

CLIENT

ORANA

SHEET TITLE

ELEVATIONS 2 OF 2


DRAWING NUMBER

A103

REVISION
A
SCALE AT A3
1 : 50

29/03/2026 12:35:36 AM

SET OUTS, LEVELS AND CRITICAL DIMENSIONS TO BE
CONFIRMED ON SITE PRIOR TO FABRICATION
DO NOT SCALE FROM THIS DRAWING, USE FIGURED
DIMENSIONS
ALL CONSTRUCTION TO COMPLY WITH NATIONAL
CONSTRUCTION CODE OF AUSTRALIA (NCC) AND
RELEVANT AUSTRALIAN STANDARDS
ALL DESIGNS © ORANA, 2026

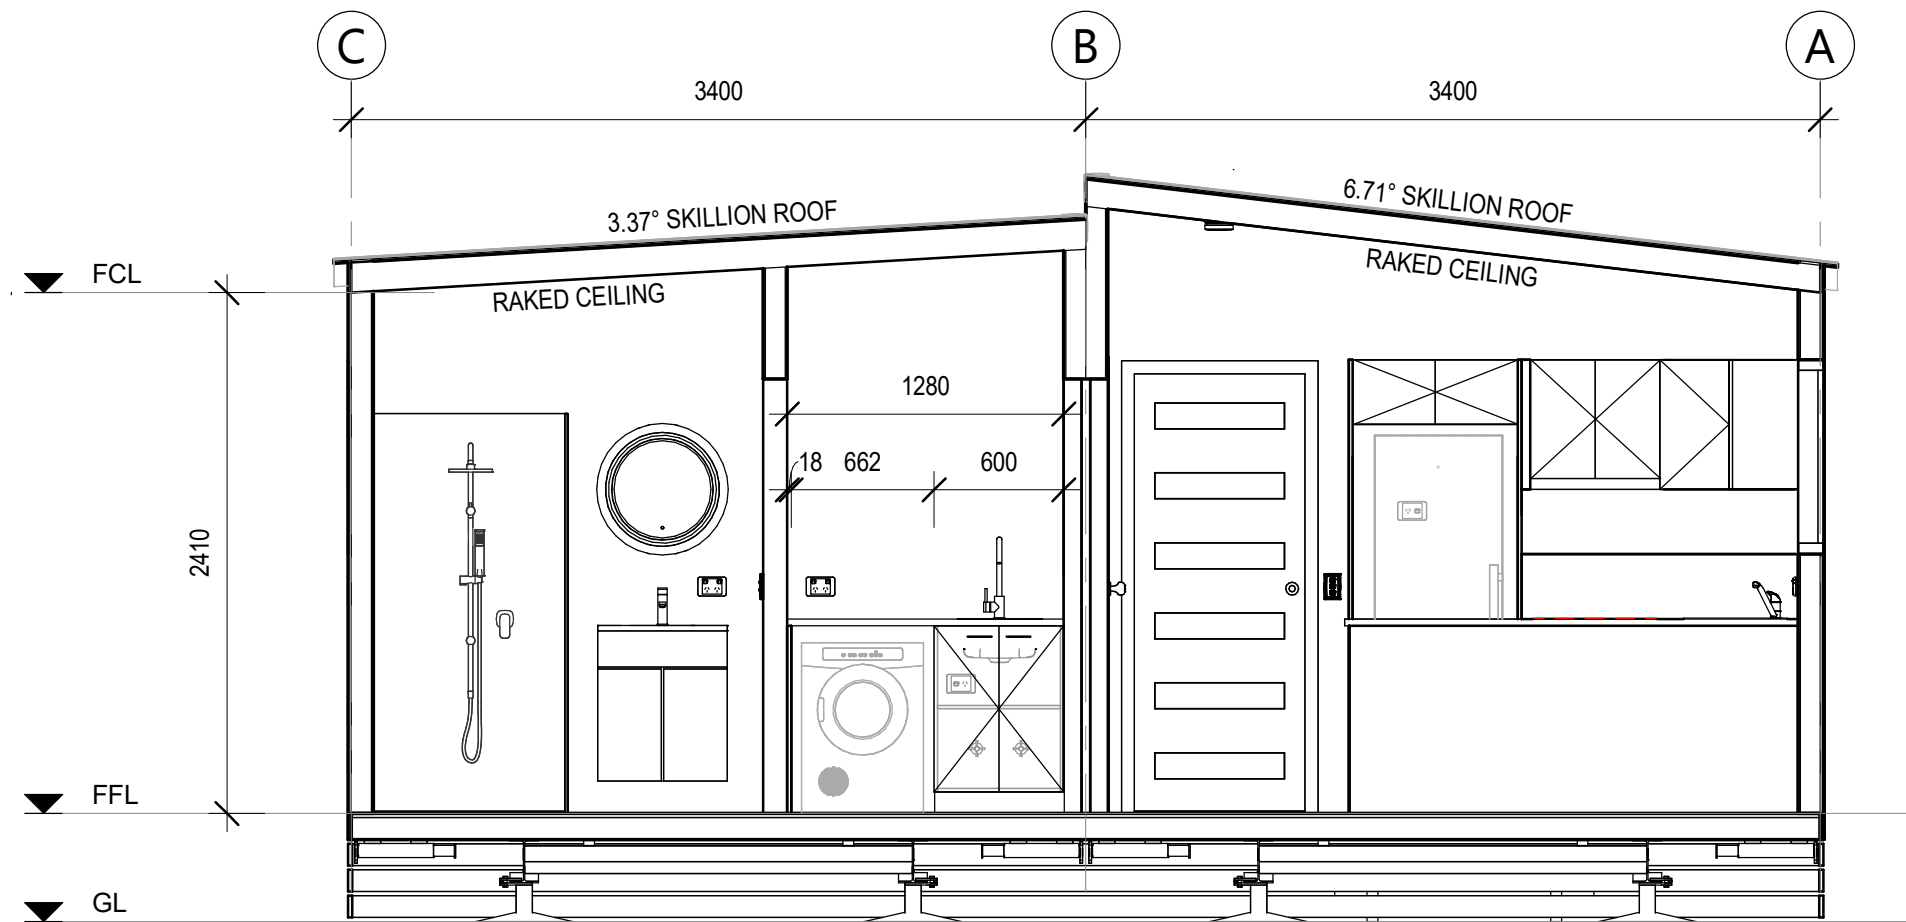

SECTION A-A

1 : 35

REVISION SCHEDULE

REV	DESCRIPTION	DATE	BY
A	ISSUED FOR REVIEW	28.03.26	DM

DRAWING STATUS

ISSUED FOR
REVIEW

ORANA

14729 Spring Avenue,
Santa Fe Springs, CA, 90670
E: hello@oranausa.com
P: 888 256 6416

BUILDING NAME

'THE AIRLIE'

DESCRIPTION

10.0 x 6.0m 2 BEDROOM
DWELLING with DECK

CLIENT

ORANA

SHEET TITLE

SECTION & INTERNAL
3D VIEWS


DRAWING NUMBER

A104

REVISION
A
SCALE AT A3
1 : 35


29/03/2026 12:35:40 AM



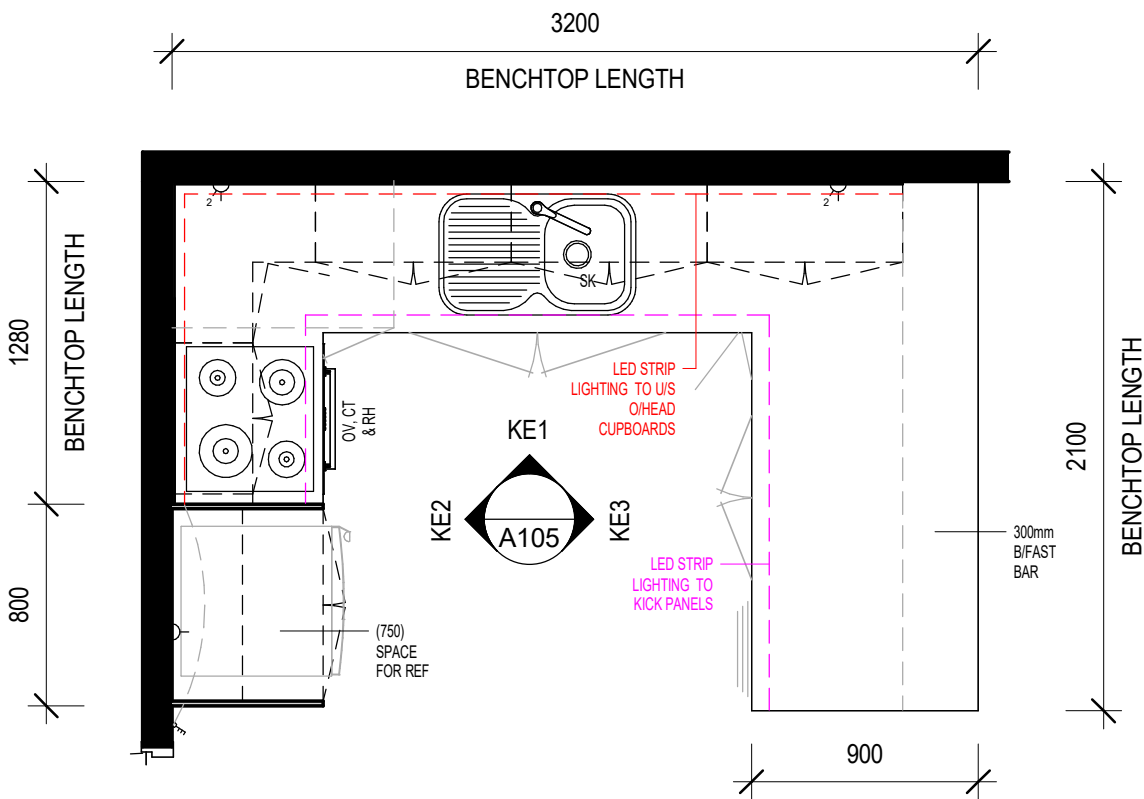


KITCHEN JOINERY - PLAN VIEW

1 : 30

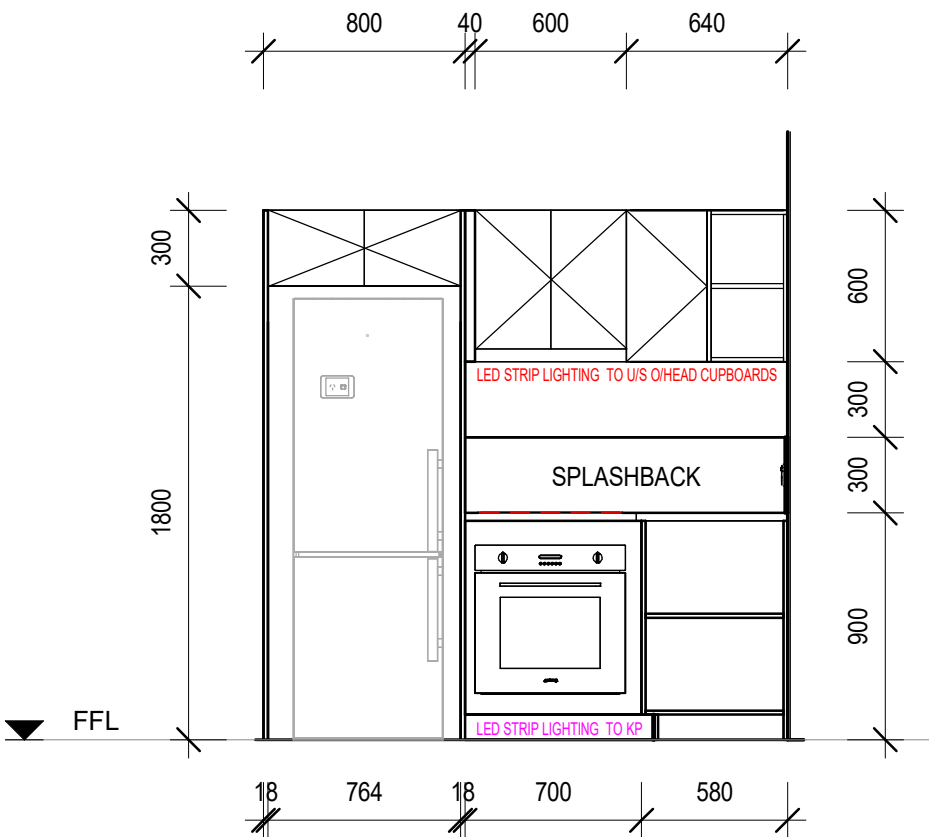


KITCHEN ELEVATION 2 (KE2)

1 : 30

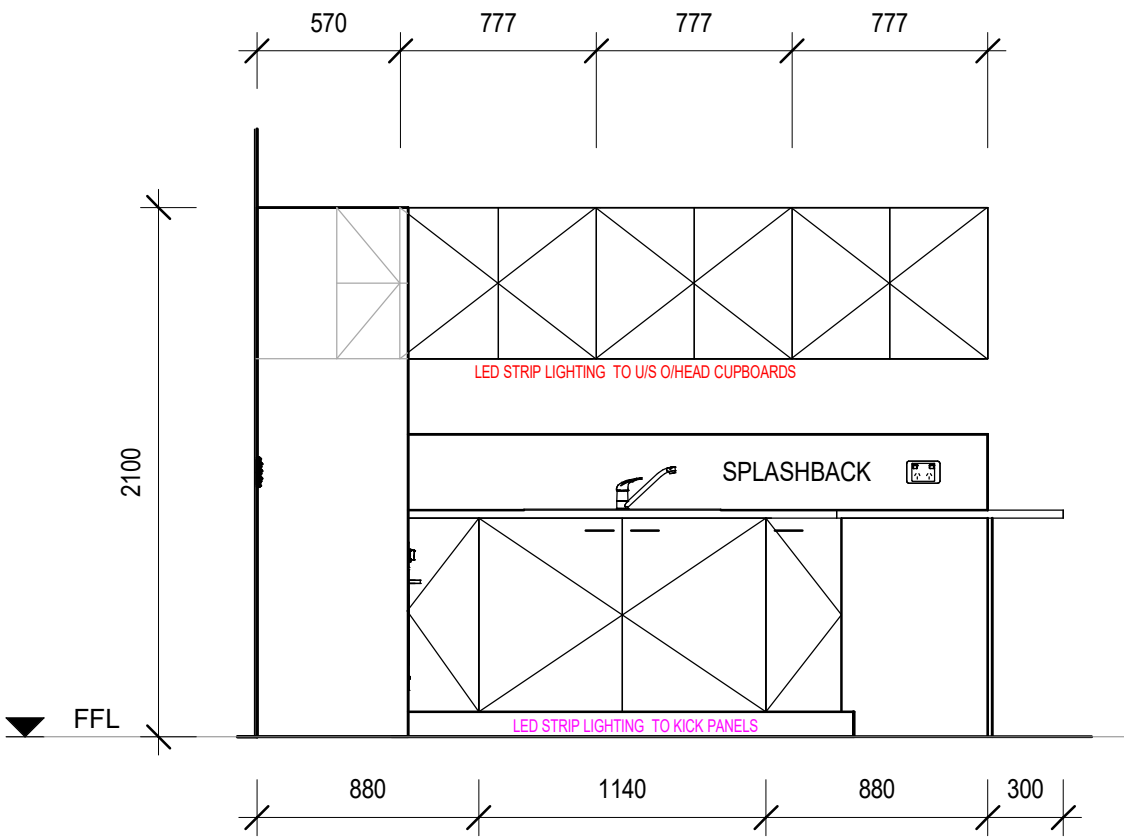

KITCHEN ELEVATION 1 (KE1)

1 : 30

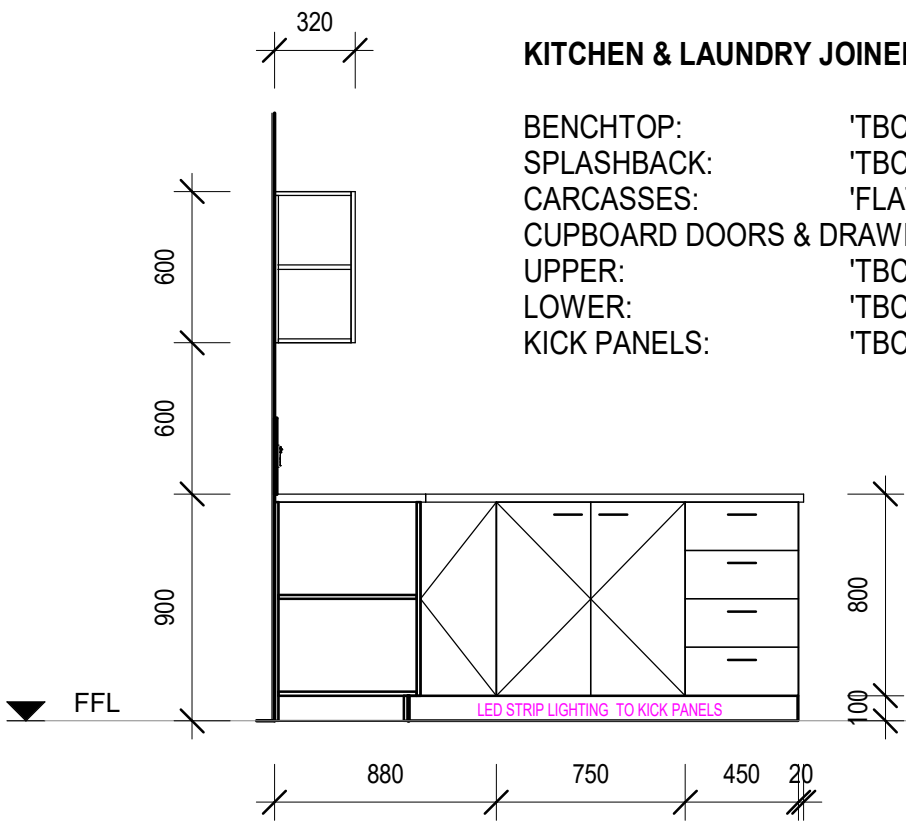

KITCHEN ELEVATION 3 (KE3)

1 : 30

KITCHEN & LAUNDRY JOINERY COLOURS

BENCHTOP: 'TBC' (30mm STONE)
SPLASHBACK: 'TBC'
CARCASSES: 'FLAT WHITE'
CUPBOARD DOORS & DRAWER FRONTS:
UPPER: 'TBC'
LOWER: 'TBC'
KICK PANELS: 'TBC'

SET OUTS, LEVELS AND CRITICAL DIMENSIONS TO BE
CONFIRMED ON SITE PRIOR TO FABRICATION
DO NOT SCALE FROM THIS DRAWING, USE FIGURED
DIMENSIONS
ALL CONSTRUCTION TO COMPLY WITH NATIONAL
CONSTRUCTION CODE OF AUSTRALIA (NCC) AND
RELEVANT AUSTRALIAN STANDARDS
ALL DESIGNS © ORANA, 2026

REVISION SCHEDULE			
REV	DESCRIPTION	DATE	BY
A	ISSUED FOR REVIEW	28.03.26	DM

DRAWING STATUS

ISSUED FOR
REVIEW

ORANA

14729 Spring Avenue,
Santa Fe Springs, CA, 90670
E: hello@oranausa.com
P: 888 256 6416

BUILDING NAME

'THE AIRLIE'

DESCRIPTION

10.0 x 6.0m 2 BEDROOM
DWELLING with DECK

CLIENT

ORANA

SHEET TITLE

KITCHEN JOINERY
DETAILS

DRAWING NUMBER

A105

REVISION
A
SCALE AT A3
1 : 30

29/03/2026 12:35:41 AM

SUB-FLOOR SYSTEM

SKID BEAMS: < W10x22 STEEL SKID BEAM SYSTEM

FLOOR SYSTEM

FLOOR FRAMING: 100 x 1.5mm LIPPED CHANNEL JOISTS @ 450mm CS
INSULATION - U/FLOOR: R15 (OR EQUIV.) MINIMUM INSULATION VALUE
FLOORING 3/4" STRUCTURAL PLYWOOD
FLOOR COVERING: SPC PLANKS (STONE PLASTIC COMPOSITE CORE)
DECKING COMPOSITE TIMBER DECKING

WALL SYSTEM

FRAMING: 92mm (OR EQUIV.) ENGINEERED STEEL FRAME

INSULATION: R15 (OR EQUIV.) MINIMUM INSULATION VALUE TO INTERNAL AND EXTERNAL WALLS

CLADDING: CHOICE OF THE FOLLOWING THEMES -
'MODERN'
'CONTEMPORARY'
'HAMPTONS'
'TRADITIONAL'

INTERNAL: 5/8" DRYWALL, SET & PAINTED

BATHROOM: LINED WITH SPC SHEETS

ROOF SYSTEM

ROOF SYSTEM: ENGINEERED STEEL FRAME/ RAFTER SYSTEM
INSULATION: R19 (OR EQUIV.) BATTS + R9 (OR EQUIV.) BLANKET OVER. TOTAL MINIMUM INSULATION VALUE = R26
ROOFING: STEEL PANEL ROOFING
INTERNAL: 5/8" DRYWALL, SET & PAINTED (SQUARE SET)

FINISHES SCHEDULE

ITEM	COLOUR	
FLOOR COVERING:		
SPC PLANKS	'TBC'	(GENERALLY)
FLOOR TILES	'TBC'	(BATHROOM)
CARPET	'TBC'	(BEDROOMS)
CLADDING:	'TBC'	
CORNER ANGLES	'TBC'	
INTERNAL FEATURE WALLS		
LIVING AREA	'TBC'	
BEDROOMS	'TBC'	
BATHROOM WALLS	'TBC'	
WALLS, GENERALLY	'BRIGHT WHITE' MATTE	(STANDARD)
CEILING	'BRIGHT WHITE' MATTE	(STANDARD)
ROOF:		
ROOF SHEET	'SHALE GREY'	
GUTTER	NIL - N/A	
FASCIA	'TBC'	
EXTERNAL DOOR:		
SWING DOOR FRAME	'TBC'	(TIMBER)
DOOR BLANK	'N/A'	
WINDOWS		
WINDOW FRAMES	'TBC'	(uPVC)

DOOR SCHEDULE									
No.	DOOR LEAF			DOOR FRAME	DOOR HARDWARE			QTY	COMMENTS
	DOOR LEAF	SIZE		FRAME	HANDLE TYPE	LOCKSET	CLOSER		
		H	W						
D1	SOLID CORE	2040	820	TIMBER	KNOB	ENTRANCE	No	1	/W GLASS PANELS
D2	HOLLOW CORE	2040	720	TIMBER	CAV	PASSAGE	No	3	CAVITY SLIDER
D3	HOLLOW CORE	2040	720	TIMBER	CAV	PRIVACY	No	2	CAVITY SLIDER
D4	HOLLOW CORE	2040	1000	TIMBER	KNOB	PASSAGE	No	1	DOUBLE DOOR

WINDOW SCHEDULE									
No.	TYPE	GLAZING	SIZE		SILL HEIGHT	FRAME	SECURITY	QTY	COMMENTS
			H	W					
W1	SLIDING	OBSCURE GLASS	600	600	1500	uPVC	-	2	
W2	SLIDING	CLEAR GLASS	900	1200	1200	uPVC	-	5	
W3	TRANSOM	CLEAR GLASS	2100	600	0	uPVC		2	

MECHANICAL SERVICES SCHEDULE			
No.	DESCRIPTION	QTY	COMMENTS
-	2 IN 1 EXHAUST FAN AND LIGHT COMBO	2	CEILING MOUNTED
AC1	2.6kW SPLI T SYSTEM AC UNIT	1	CONDENSING UNIT INSTALLED ON SITE
RH	UNDERMOUNT RANGEHOOD, 60cm	1	

FITTINGS SCHEDULE		
ITEM	DESCRIPTION	QTY
Electrical Fixtures		
-	GPO, 1x10A	2
-	GPO, 2x10A	11
-	ISOLATION SWITCH 1x20A FOR AC UNIT	1
-	SMOKE DETECTOR 120V, HARDWIRED WITH BATTERY BACKUP	2
DSB	SWITCHBOARD & ELEC. POINT OF ENTRY	1
Lighting Fixtures		
-	DOWNLIGHT - LED	8
-	LIGHT SWITCH, 4 GANG with SWITCH FOR KITCHEN STRIP LIGHTING	1
-	LIGHT SWITCH, SINGLE	3
-	SWITCH FOR 2-IN-1 EXH FAN/LIGHT COMBO	2
Plumbing Fixtures		
-	LAUNDRY MIXER TAP	1
-	RAIL SHOWER WITH HEAD AND WAND	2
-	SHOWER MIXER TAP	2

FITTINGS SCHEDULE		
ITEM	DESCRIPTION	QTY
-	WASHING MACHINE TAPSET	1
fw	FLOOR WASTE	2
SHW	SEMI-FRAMELESS GLASS SHOWER SCREEN, NO DOOR, 1200x900mm	2
SK	SINK, 1 BOWL, 1 DRAIN - 780mm LONG	1
T	COMPACT LAUNDRY TUB, 35L	1
VB	VANITY, 2 DOOR - 600W x 320D (TEAK OAK FINISH)	2
WC	WC SUITE, RIMLESS, B2W (CERAMIC BOWL)	2
Specialty Equipment		
CT	60cm ELECTRIC COOKTOP	1
MIR	WALL MOUNTED LED MIRROR	2
OV	60cm ELECTRIC BUILT-IN OVEN	1
REF	PROVISION FOR FRIDGE	1
TR	TOWEL RAIL, 600mm LONG	2
TRH	TOILET ROLL HOLDER	2
WM	PROVISION FOR WASHING MACHINE	1

INCLUSIONS ARE INDICATIVE ONLY, TO BE DISCUSSED
TAPWARE FOR SINK, VANITIES, TOWEL RAIL, TOILET ROLL HOLDER, SHOWER HEAD AND RAIL - GRAPHITE (STANDARD)
KITCHEN SINK - GRAPHITE (STANDARD)

SET OUTS, LEVELS AND CRITICAL DIMENSIONS TO BE
CONFIRMED ON SITE PRIOR TO FABRICATION
DO NOT SCALE FROM THIS DRAWING, USE FIGURED
DIMENSIONS
ALL CONSTRUCTION TO COMPLY WITH NATIONAL
CONSTRUCTION CODE OF AUSTRALIA (NCC) AND
RELEVANT AUSTRALIAN STANDARDS
ALL DESIGNS © ORANA, 2026

REVISION SCHEDULE			
REV	DESCRIPTION	DATE	BY
A	ISSUED FOR REVIEW	28.03.26	DM

DRAWING STATUS

ISSUED FOR
REVIEW

ORANA

14729 Spring Avenue,
Santa Fe Springs, CA, 90670
E: hello@oranausa.com
P: 888 256 6416

BUILDING NAME

'THE AIRLIE'

DESCRIPTION
10.0 x 6.0m 2 BEDROOM
DWELLING with DECK

CLIENT
ORANA

SHEET TITLE
SCHEDULES

DRAWING NUMBER
A106
SCALE AT A3

REVISION
A

