



DRAWING LIST

SHEET NUMBER	SHEET NAME	CURRENT REVISION
A000	TITLE PAGE	A
A101	FLOOR PLAN	A
A102	ELEVATIONS 1 OF 2	A
A103	ELEVATIONS 2 OF 2	A
A104	SECTIONS & INTERNAL 3D VIEWS	A
A105	KITCHEN JOINERY DETAILS (PART A)	A
A106	KITCHEN JOINERY DETAILS (PART B)	A
A107	LAUNDRY JOINERY DETAILS	A
A108	SCHEDULES	A



ORANA

3 BEDROOM DWELLING WITH BREEZEWAY

'THE BREEZE'

ORANA

14729 Spring Avenue,
Santa Fe Springs, CA, 90670
E: hello@oranausa.com
P: 888 256 6416

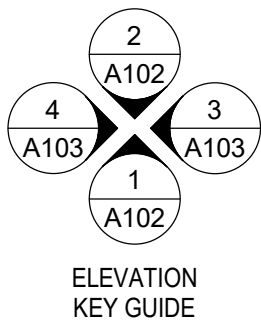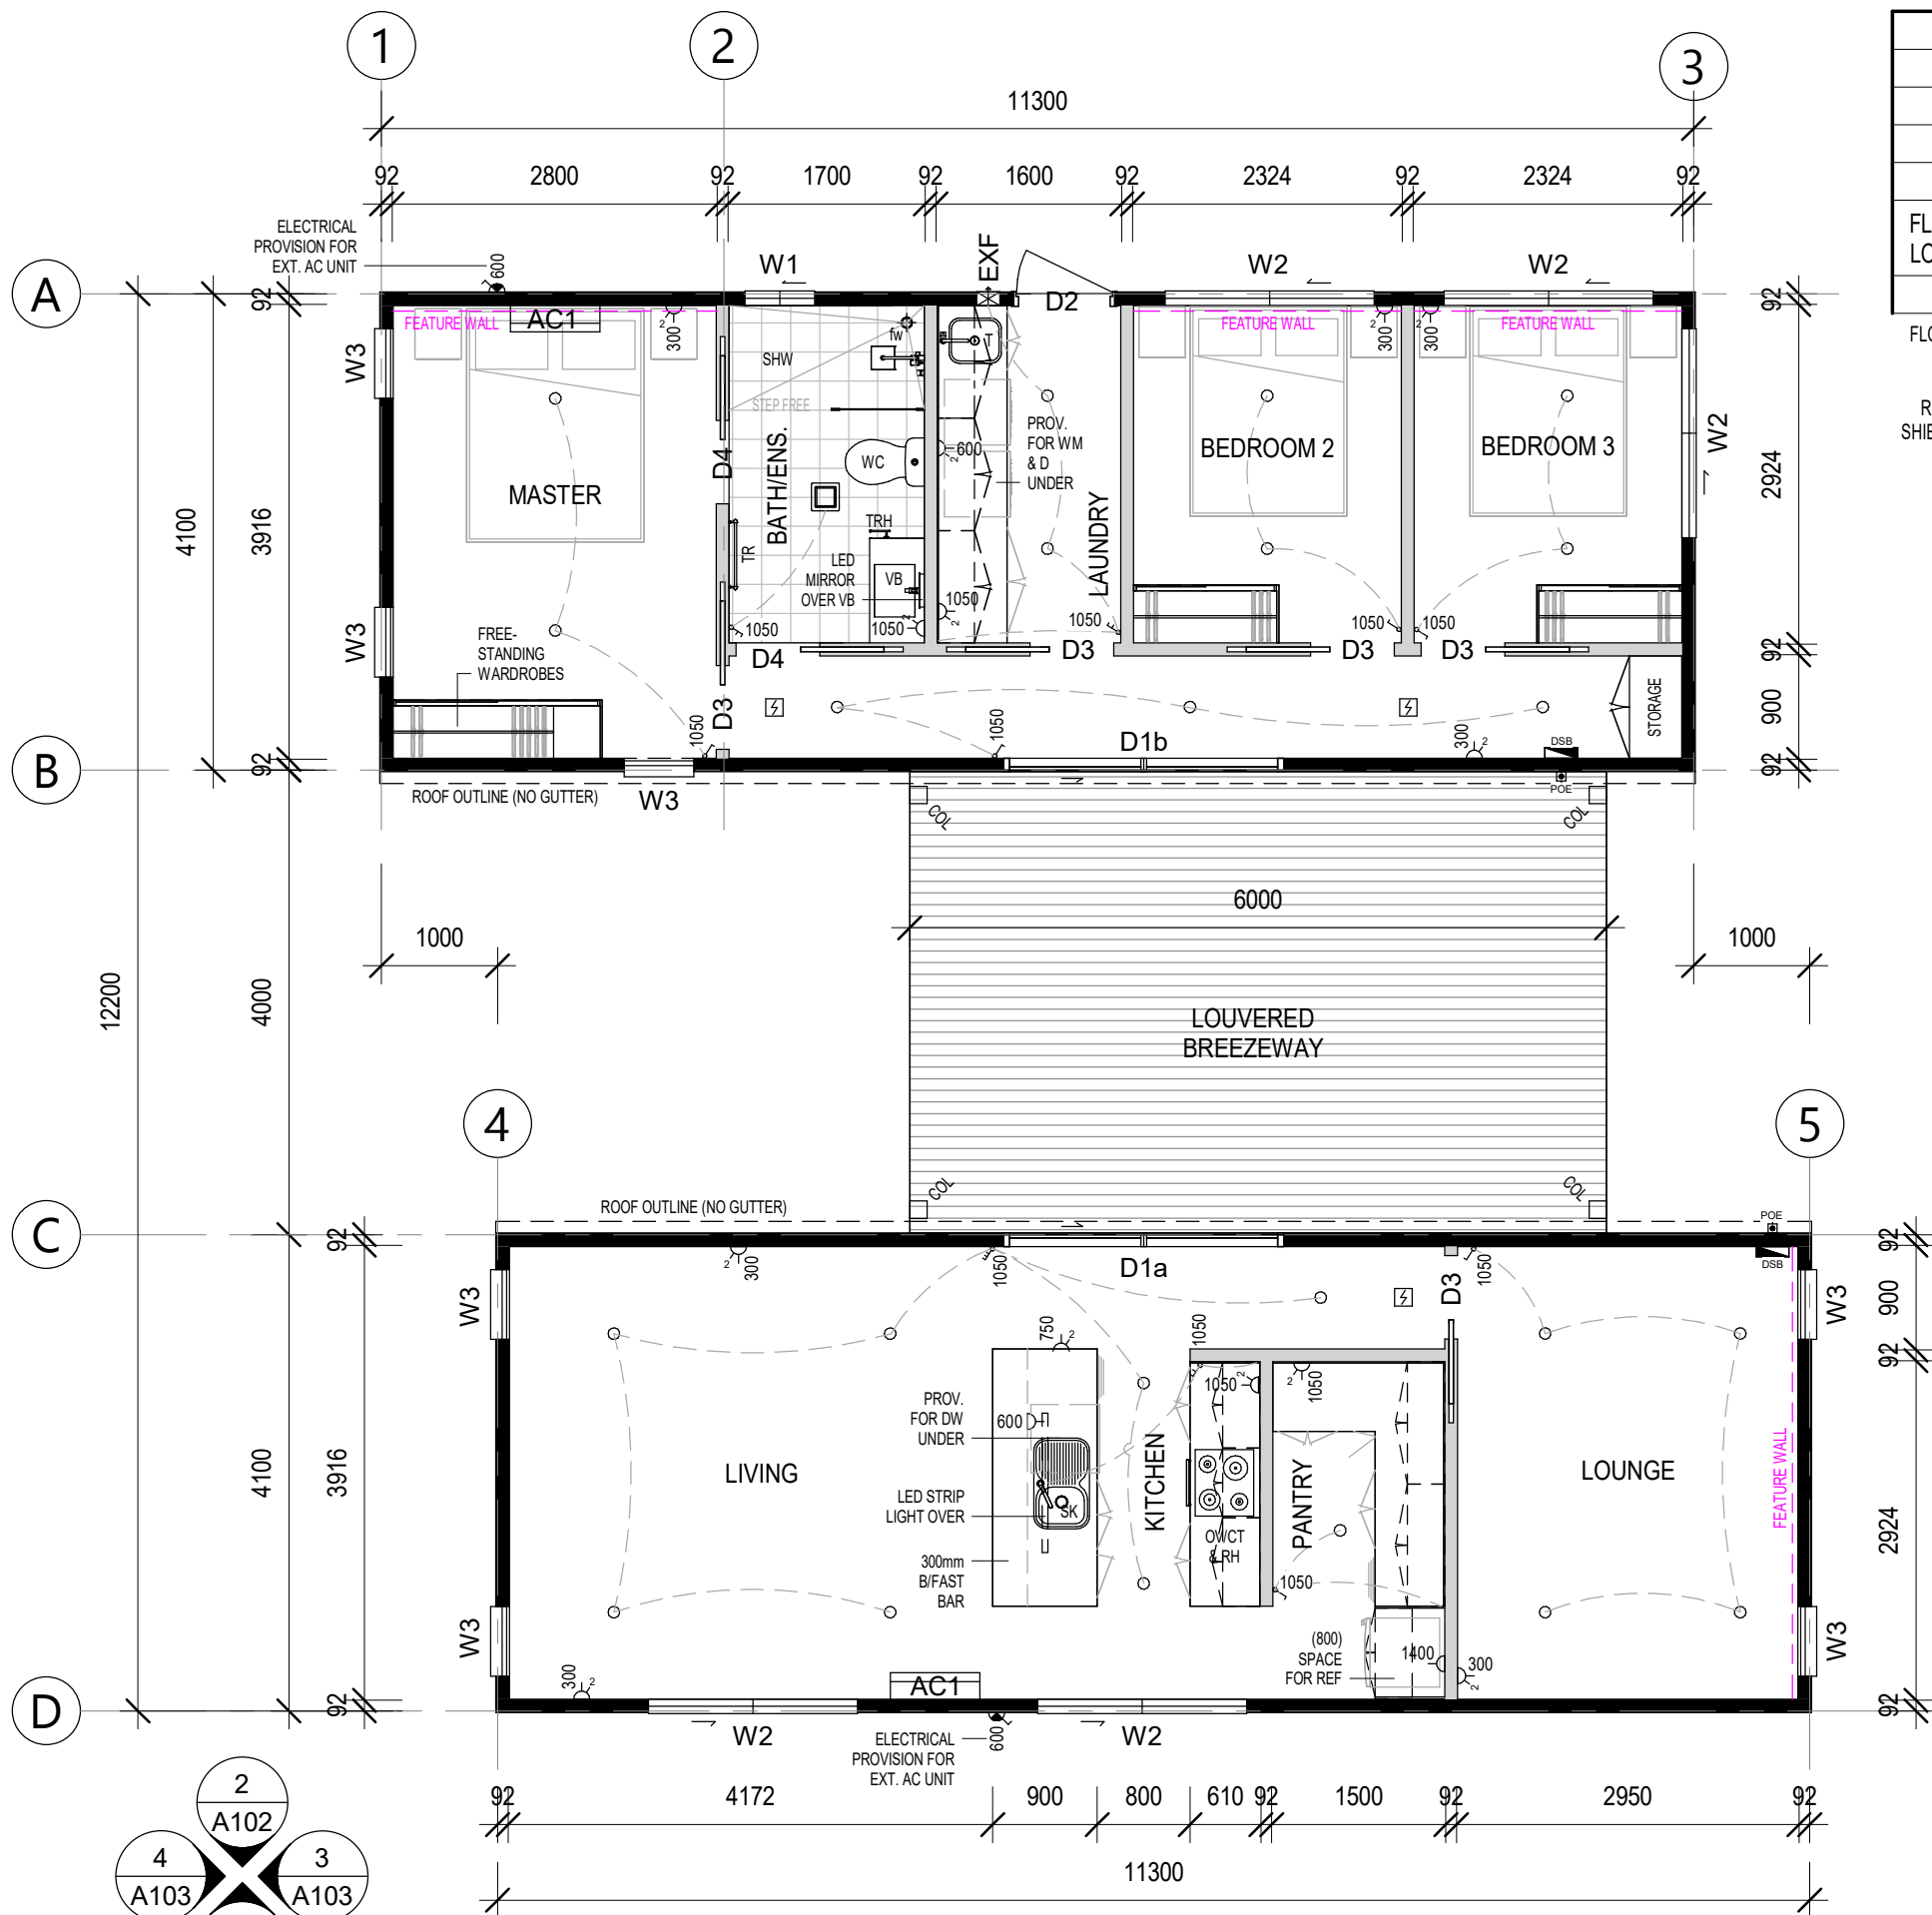

FLOOR PLAN
1 : 65

WIND REGION:			 NORTH
TERRAIN CATEGORY:			
IMPORTANCE LEVEL:			
SHIELDING FACTOR:			
BUILDING CLASS:		1a	
FLOOR LOADS	DISTRIBUTED (kPa):	1.5	
	CONCENTRATED (kN):	1.2	
CLIMATE ZONE:			

FLOOR LOADS CALCULATED FROM AS1170.1 - 2002. WIND SPEED CALCULATED FROM AS1170.2 - 2021. BUILDING CLASS, IMPORTANCE LEVEL, PROBABILITY OF EXCEEDANCE, WIND REGION, TERRAIN CATEGORY, TOPOGRAPHIC CLASIFICATION, SHIELDING FACTOR, CLIMATE ZONE & NORTH POINT ARE ASSUMED UNLESS OTHERWISE ADVISED BY CLIENT.

ELECTRICAL SYMBOL LEGEND

- DSB ELECTRICAL SWITCHBOARD
- POE ELECTRICAL POINT OF ENTRY
- Light switch symbols: SINGLE, TWO GANG, FAN/LIGHT SWITCH
- GPO symbols: 1 x 10AMP, 2 x 10AMP
- 20AMP AC ISOLATION SWITCH
- LED DOWNLIGHT
- 240V SMOKE ALARM

SET OUTS, LEVELS AND CRITICAL DIMENSIONS TO BE CONFIRMED ON SITE PRIOR TO FABRICATION
DO NOT SCALE FROM THIS DRAWING, USE FIGURED DIMENSIONS
ALL CONSTRUCTION TO COMPLY WITH NATIONAL CONSTRUCTION CODE OF AUSTRALIA (NCC) AND RELEVANT AUSTRALIAN STANDARDS
ALL DESIGNS © ORANA, 2026

REVISION SCHEDULE			
REV	DESCRIPTION	DATE	BY
A	ISSUED FOR REVIEW	28.03.26	DM

DRAWING STATUS

ISSUED FOR REVIEW

ORANA

14729 Spring Avenue,
Santa Fe Springs, CA, 90670
E: hello@oranausa.com
P: 888 256 6416

BUILDING NAME

'THE BREEZE'

DESCRIPTION

3 BEDROOM DWELLING
WITH BREEZEWAY

CLIENT

ORANA

SHEET TITLE

FLOOR PLAN

DRAWING NUMBER


A101

REVISION

A


SCALE AT A3
As indicated

29/03/2026 3:08:45 AM

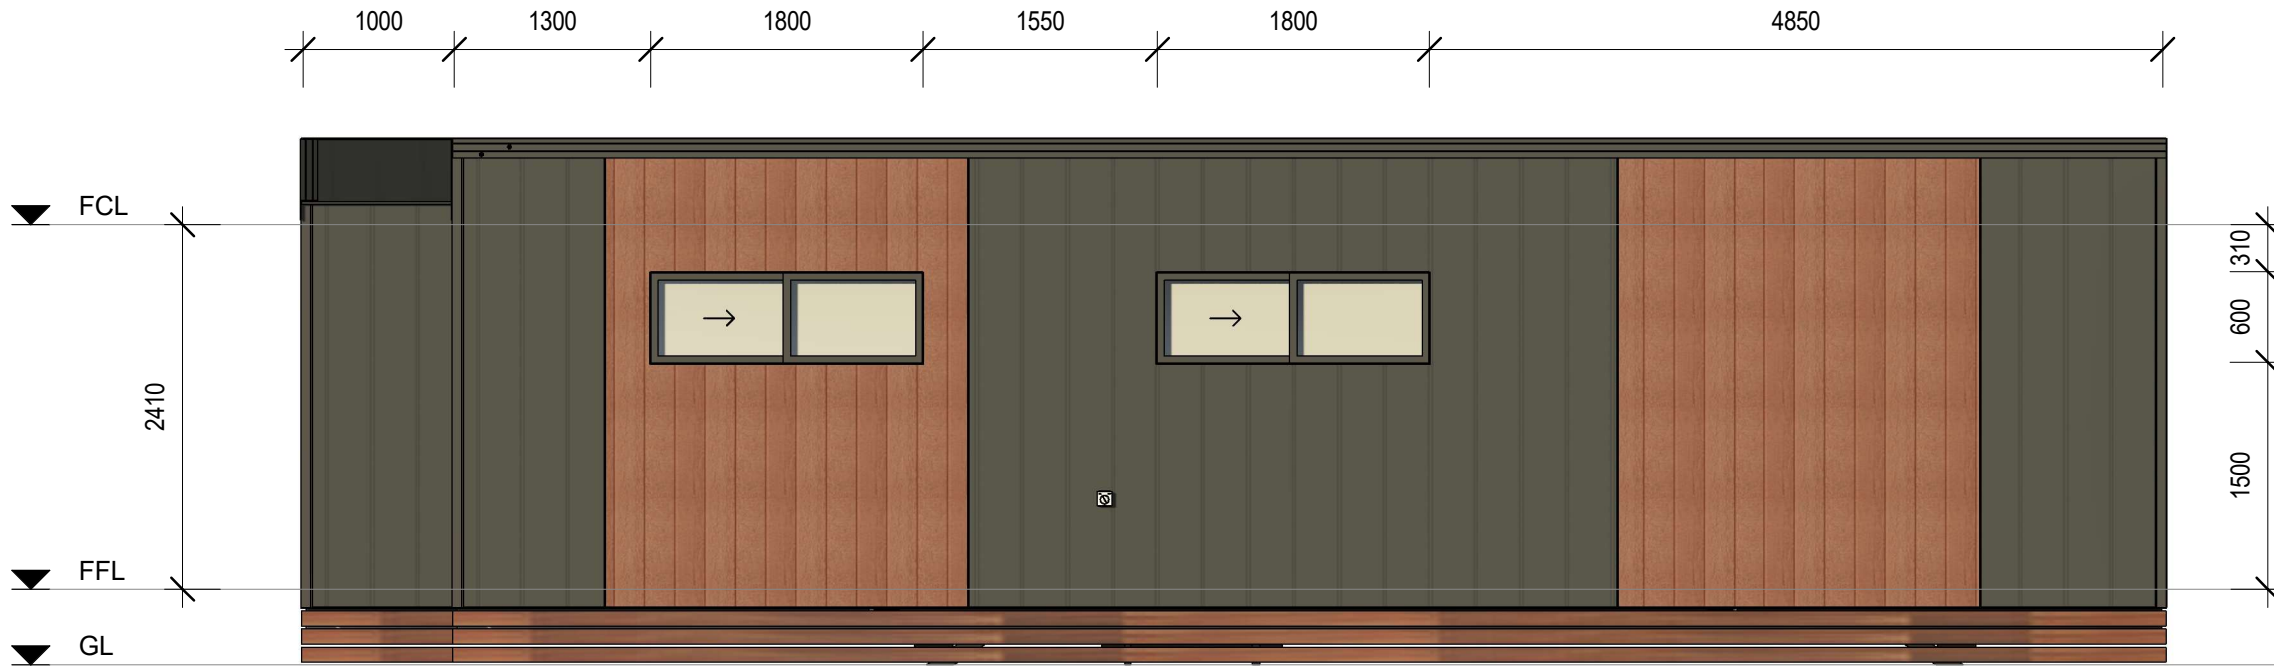

FRONT ELEVATION (1)

1 : 50

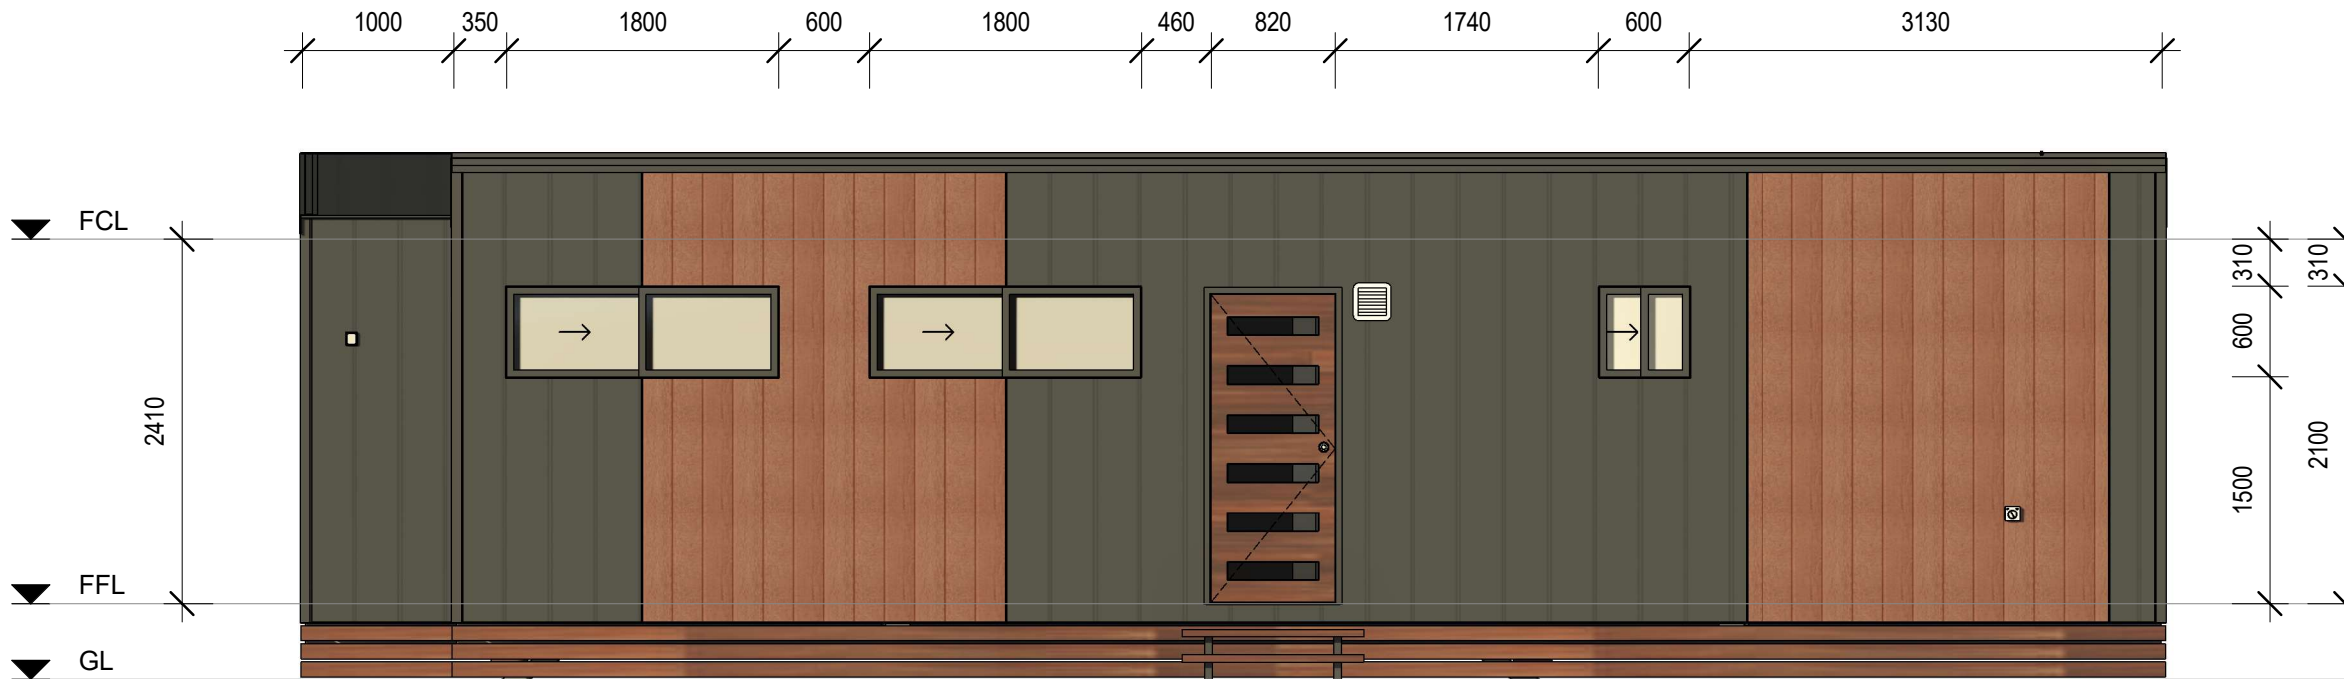

REAR ELEVATION (2)

1 : 50

SET OUTS, LEVELS AND CRITICAL DIMENSIONS TO BE
CONFIRMED ON SITE PRIOR TO FABRICATION
DO NOT SCALE FROM THIS DRAWING, USE FIGURED
DIMENSIONS
ALL CONSTRUCTION TO COMPLY WITH NATIONAL
CONSTRUCTION CODE OF AUSTRALIA (NCC) AND
RELEVANT AUSTRALIAN STANDARDS
ALL DESIGNS © ORANA, 2026

REVISION SCHEDULE			
REV	DESCRIPTION	DATE	BY
A	ISSUED FOR REVIEW	28.03.26	DM

DRAWING STATUS

ISSUED FOR
REVIEW

ORANA

14729 Spring Avenue,
Santa Fe Springs, CA, 90670
E: hello@oranausa.com
P: 888 256 6416

BUILDING NAME

'THE BREEZE'

DESCRIPTION

3 BEDROOM DWELLING
WITH BREEZEWAY

CLIENT

ORANA

SHEET TITLE


ELEVATIONS 1 OF 2

DRAWING NUMBER

A102


REVISION
A
SCALE AT A3
1 : 50

29/03/2026 3:08:47 AM

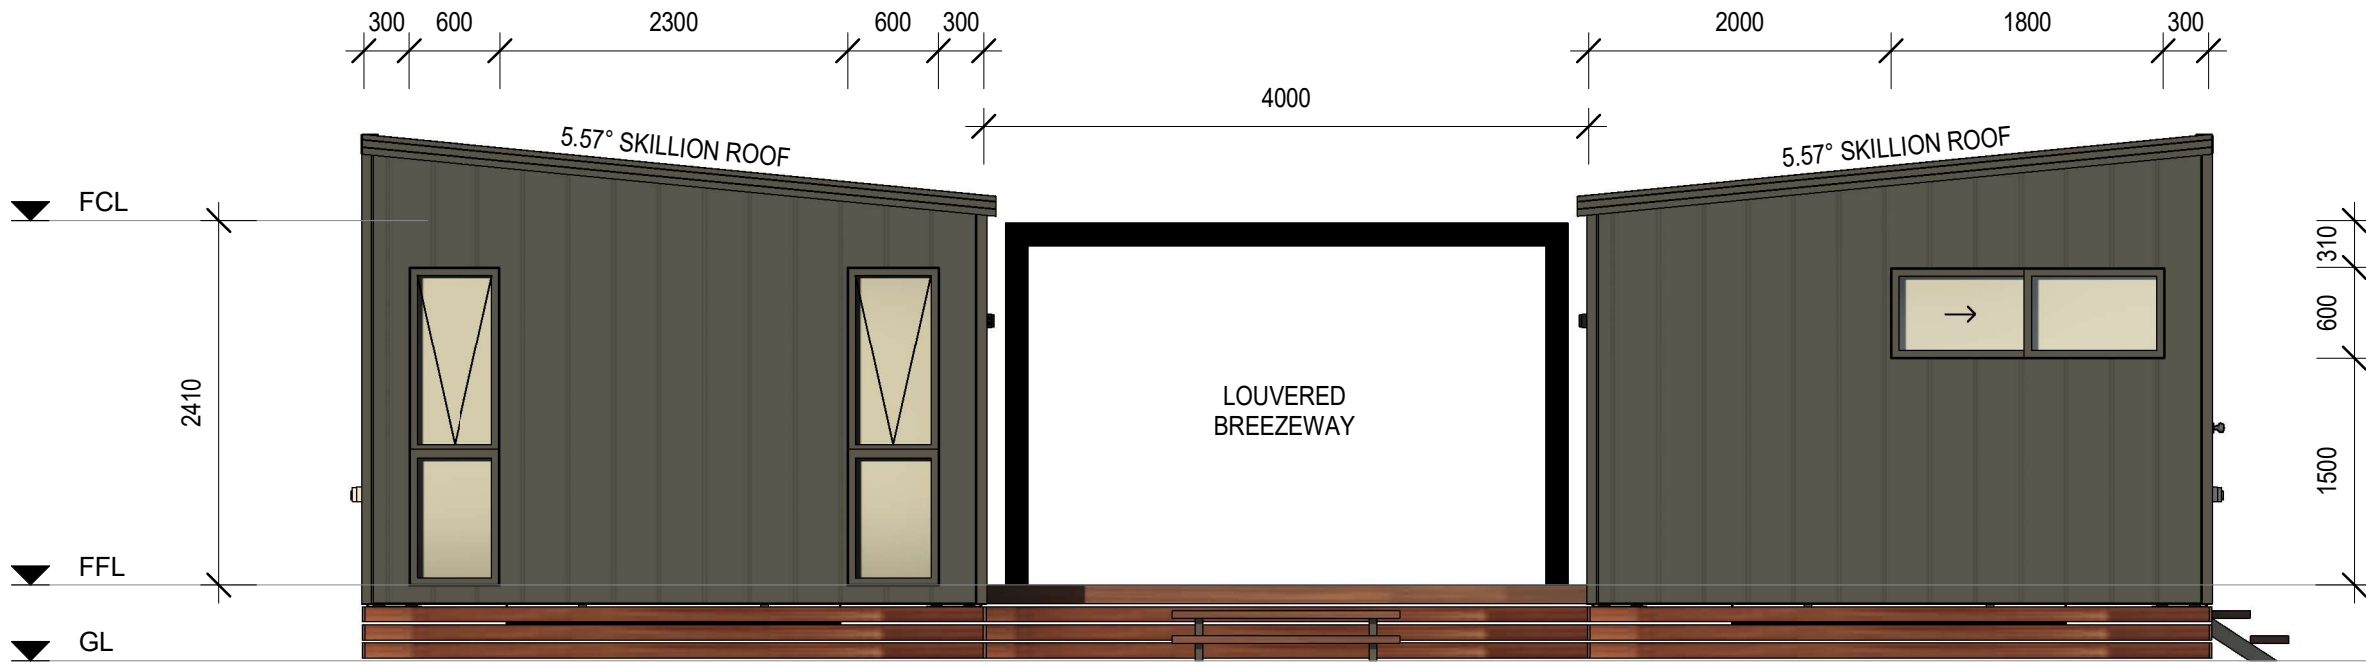

RIGHT ELEVATION (3)

1 : 50

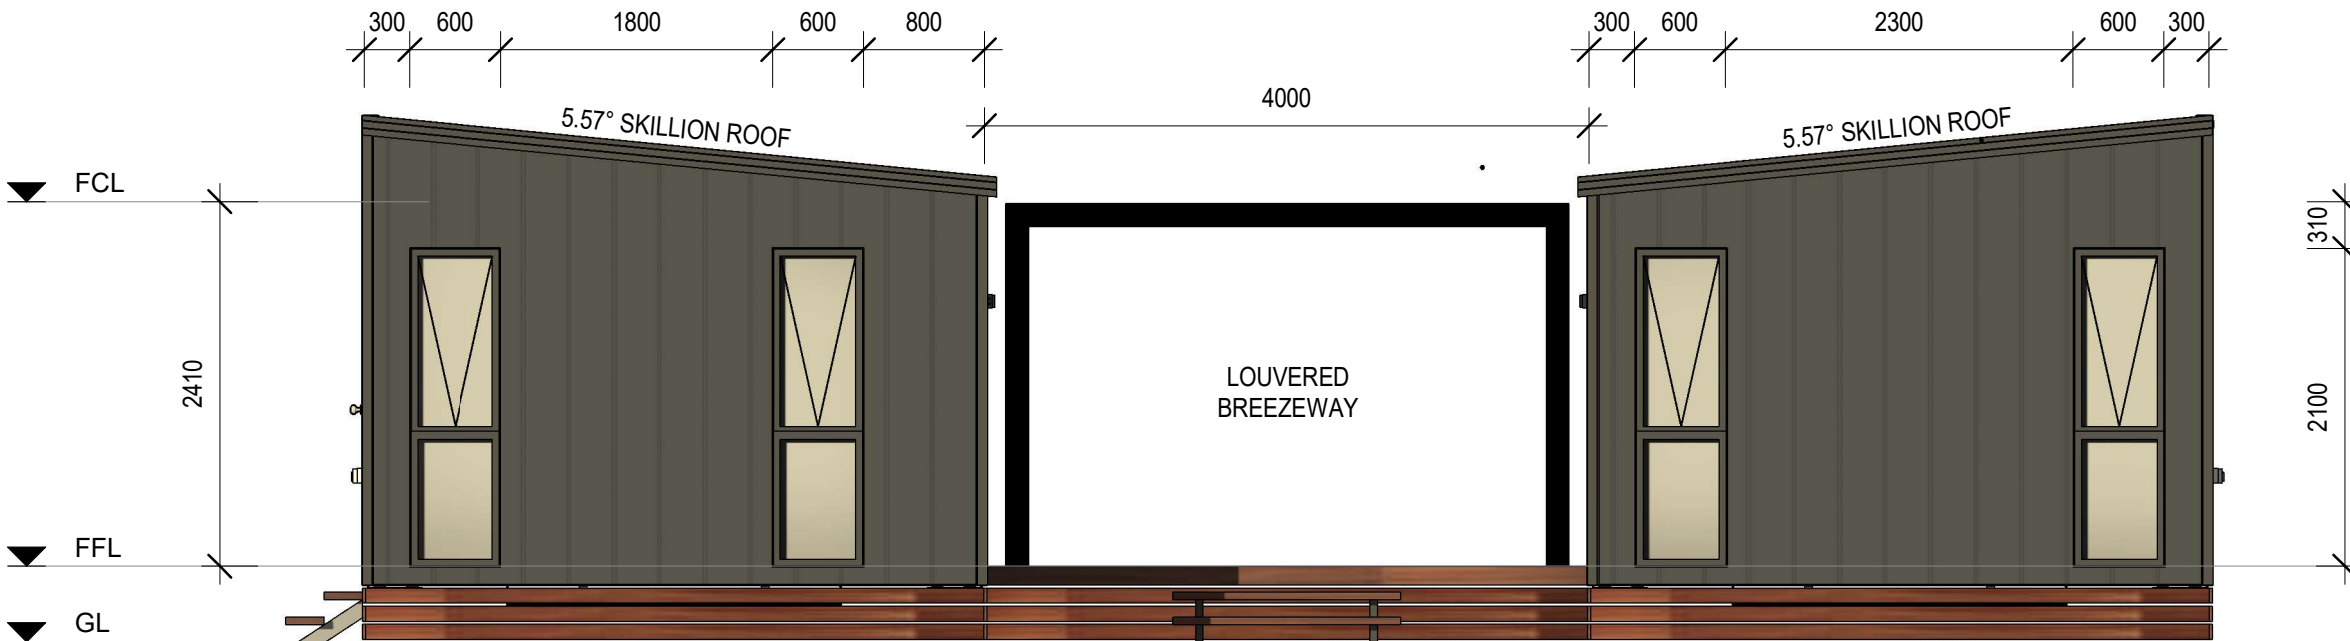

LEFT ELEVATION (4)

1 : 50

SET OUTS, LEVELS AND CRITICAL DIMENSIONS TO BE
CONFIRMED ON SITE PRIOR TO FABRICATION
DO NOT SCALE FROM THIS DRAWING, USE FIGURED
DIMENSIONS
ALL CONSTRUCTION TO COMPLY WITH NATIONAL
CONSTRUCTION CODE OF AUSTRALIA (NCC) AND
RELEVANT AUSTRALIAN STANDARDS
ALL DESIGNS © ORANA, 2026

REVISION SCHEDULE			
REV	DESCRIPTION	DATE	BY
A	ISSUED FOR REVIEW	28.03.26	DM

DRAWING STATUS

ISSUED FOR
REVIEW

ORANA


14729 Spring Avenue,
Santa Fe Springs, CA, 90670
E: hello@oranausa.com
P: 888 256 6416

BUILDING NAME	'THE BREEZE'
DESCRIPTION	3 BEDROOM DWELLING WITH BREEZEWAY
CLIENT	ORANA

SHEET TITLE	ELEVATIONS 2 OF 2
-------------	-------------------

DRAWING NUMBER	REVISION A SCALE AT A3 1 : 50
A103	

29/03/2026 3:08:50 AM

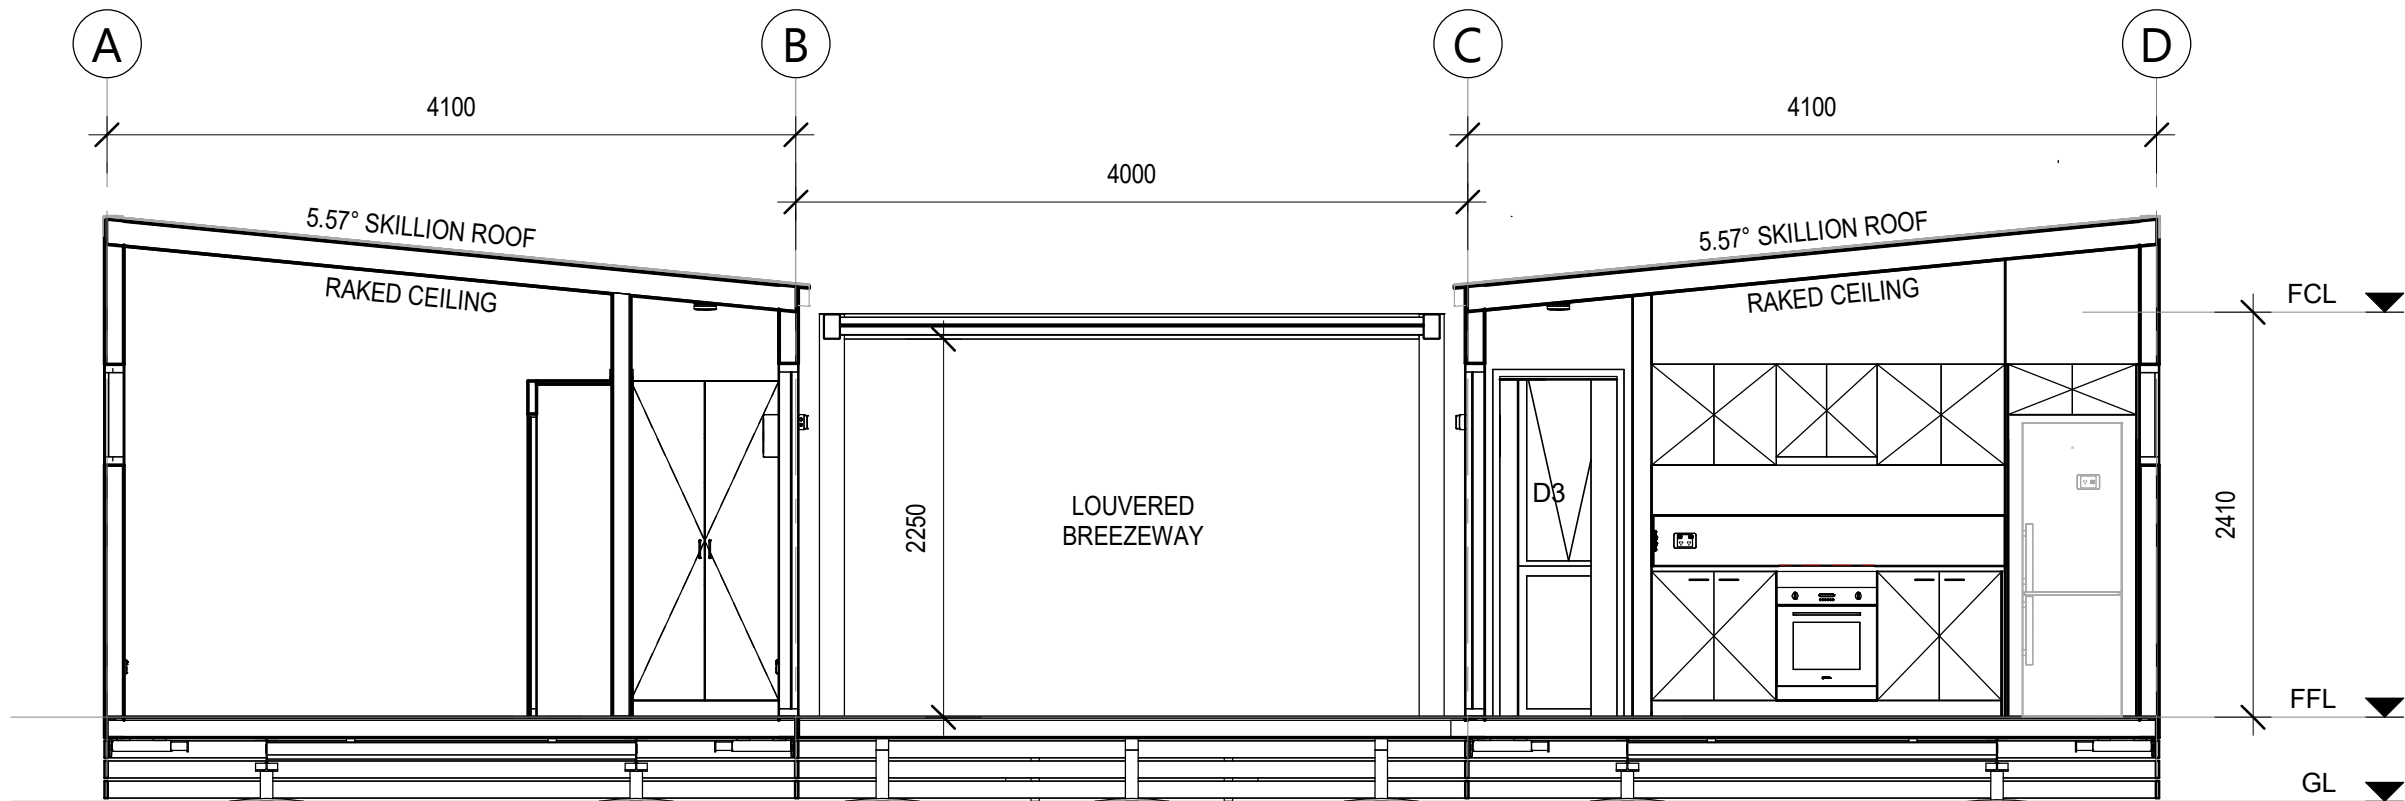

SET OUTS, LEVELS AND CRITICAL DIMENSIONS TO BE
CONFIRMED ON SITE PRIOR TO FABRICATION
DO NOT SCALE FROM THIS DRAWING, USE FIGURED
DIMENSIONS
ALL CONSTRUCTION TO COMPLY WITH NATIONAL
CONSTRUCTION CODE OF AUSTRALIA (NCC) AND
RELEVANT AUSTRALIAN STANDARDS
ALL DESIGNS © ORANA, 2026

REVISION SCHEDULE			
REV	DESCRIPTION	DATE	BY
A	ISSUED FOR REVIEW	28.03.26	DM

DRAWING STATUS

**ISSUED FOR
REVIEW**

ORANA

14729 Spring Avenue,
Santa Fe Springs, CA, 90670
E: hello@oranausa.com
P: 888 256 6416

BUILDING NAME

'THE BREEZE'

DESCRIPTION

**3 BEDROOM DWELLING
WITH BREEZEWAY**

CLIENT

ORANA

SHEET TITLE


**SECTIONS &
INTERNAL 3D VIEWS**


DRAWING NUMBER

A104

REVISION
A
SCALE AT A3
1 : 45


29/03/2026 3:08:53 AM

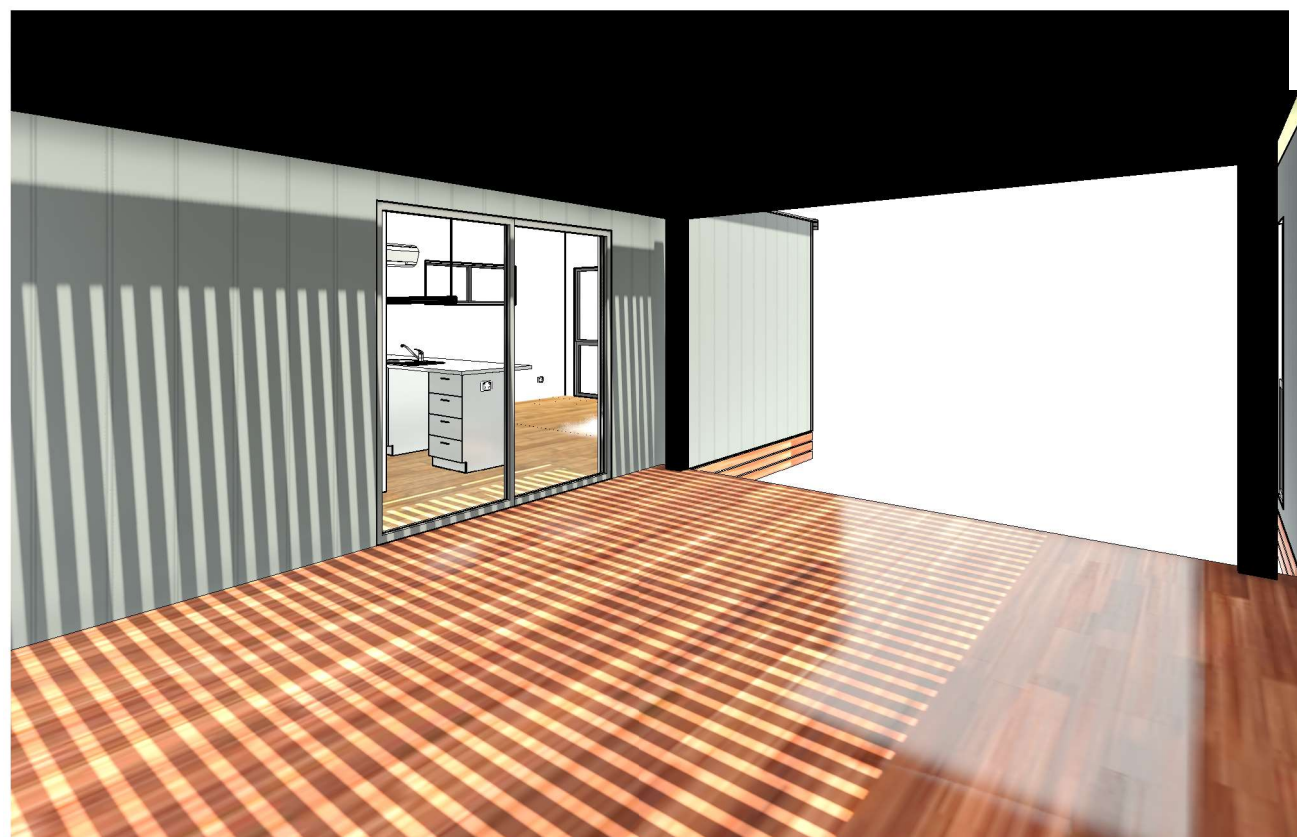

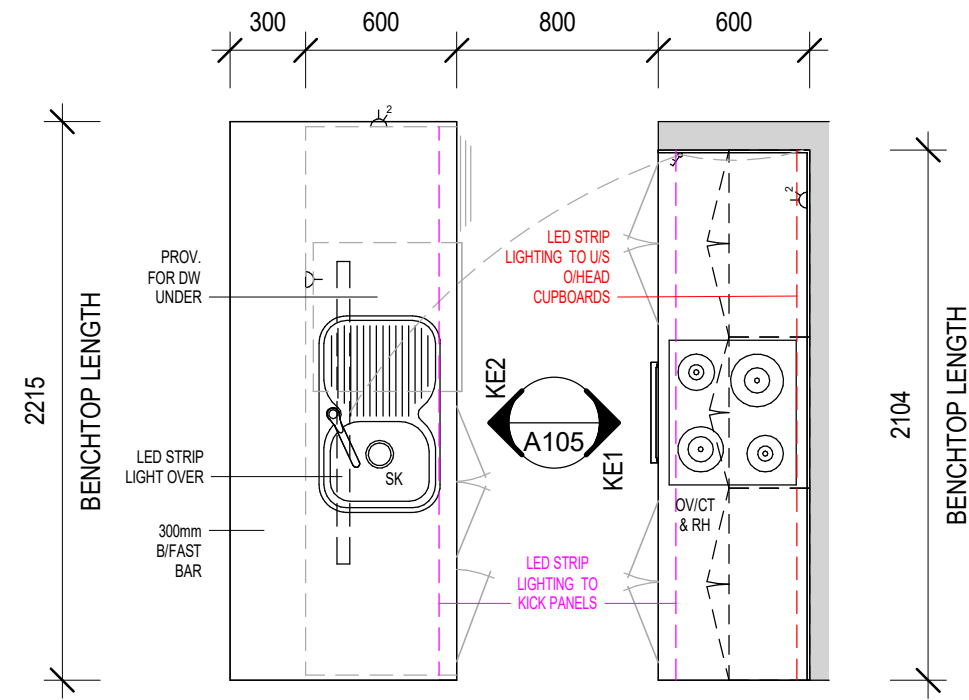


KITCHEN PART A - PLAN VIEW

1 : 30

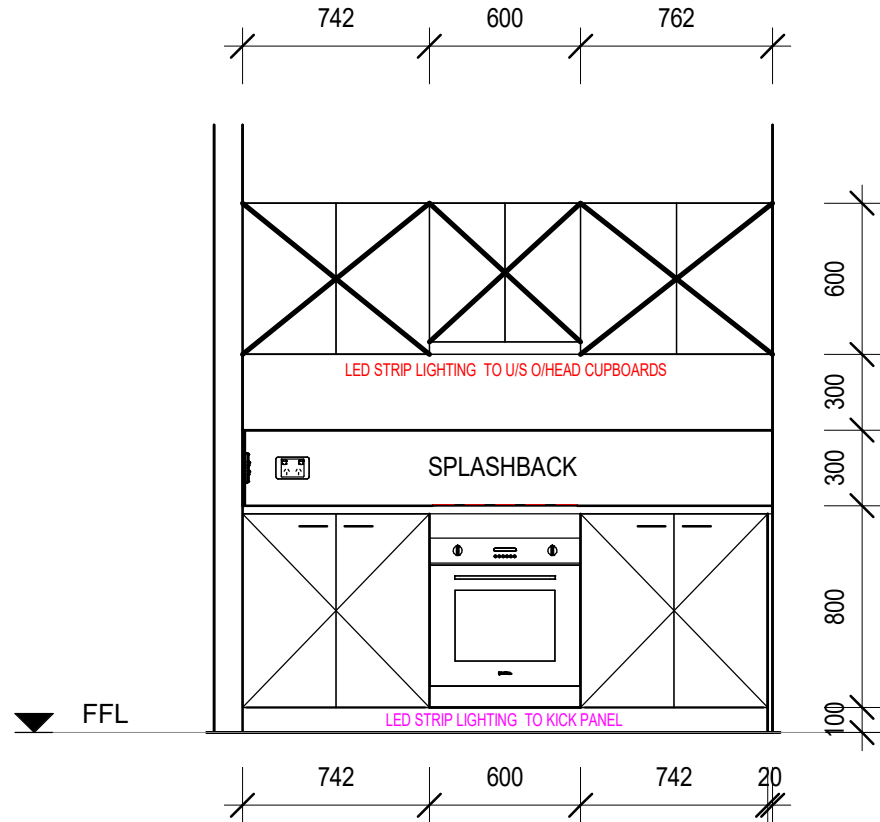

KITCHEN ELEVATION 1 (KE1)

1 : 30

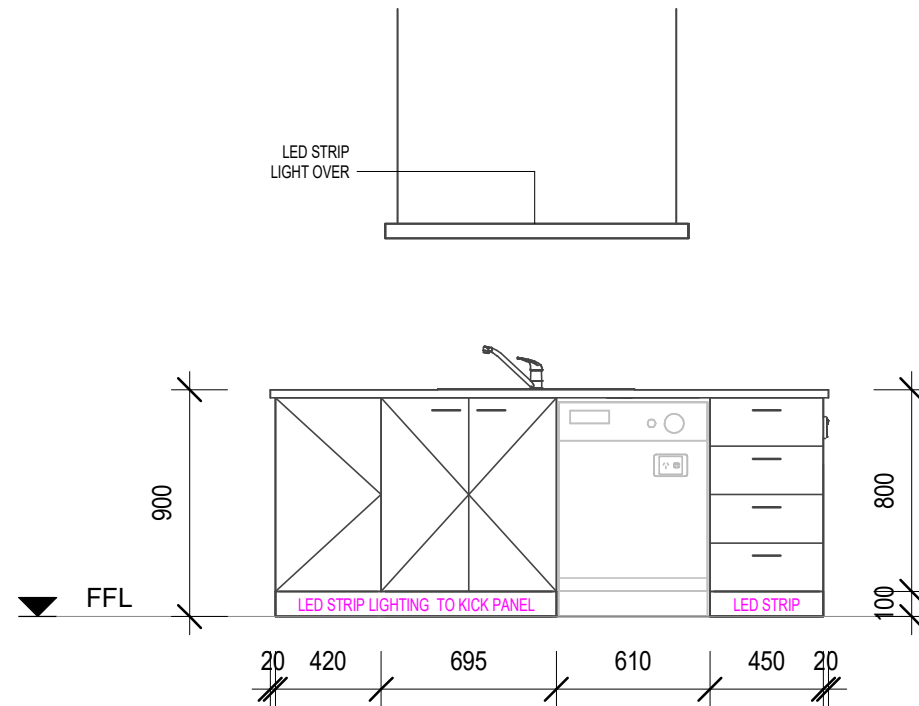

KITCHEN ELEVATION 2 (KE2)

1 : 30

KITCHEN JOINERY COLOURS

BENCHTOP: 'TBC' (30mm STONE)
SPLASHBACK: 'TBC'
CARCASSES: 'FLAT WHITE'
CUPBOARD DOORS & DRAWER FRONTS:
UPPER: 'TBC'
LOWER: 'TBC'
KICK PANELS: 'TBC'

SET OUTS, LEVELS AND CRITICAL DIMENSIONS TO BE
CONFIRMED ON SITE PRIOR TO FABRICATION
DO NOT SCALE FROM THIS DRAWING, USE FIGURED
DIMENSIONS
ALL CONSTRUCTION TO COMPLY WITH NATIONAL
CONSTRUCTION CODE OF AUSTRALIA (NCC) AND
RELEVANT AUSTRALIAN STANDARDS
ALL DESIGNS © ORANA, 2026

REVISION SCHEDULE			
REV	DESCRIPTION	DATE	BY
A	ISSUED FOR REVIEW	28.03.26	DM

DRAWING STATUS

**ISSUED FOR
REVIEW**

ORANA

14729 Spring Avenue,
Santa Fe Springs, CA, 90670
E: hello@oranausa.com
P: 888 256 6416

BUILDING NAME

'THE BREEZE'

DESCRIPTION

3 BEDROOM DWELLING
WITH BREEZEWAY

CLIENT

ORANA

SHEET TITLE


KITCHEN JOINERY
DETAILS (PART A)

DRAWING NUMBER

A105


REVISION
A
SCALE AT A3
1 : 30

29/03/2026 3:08:55 AM

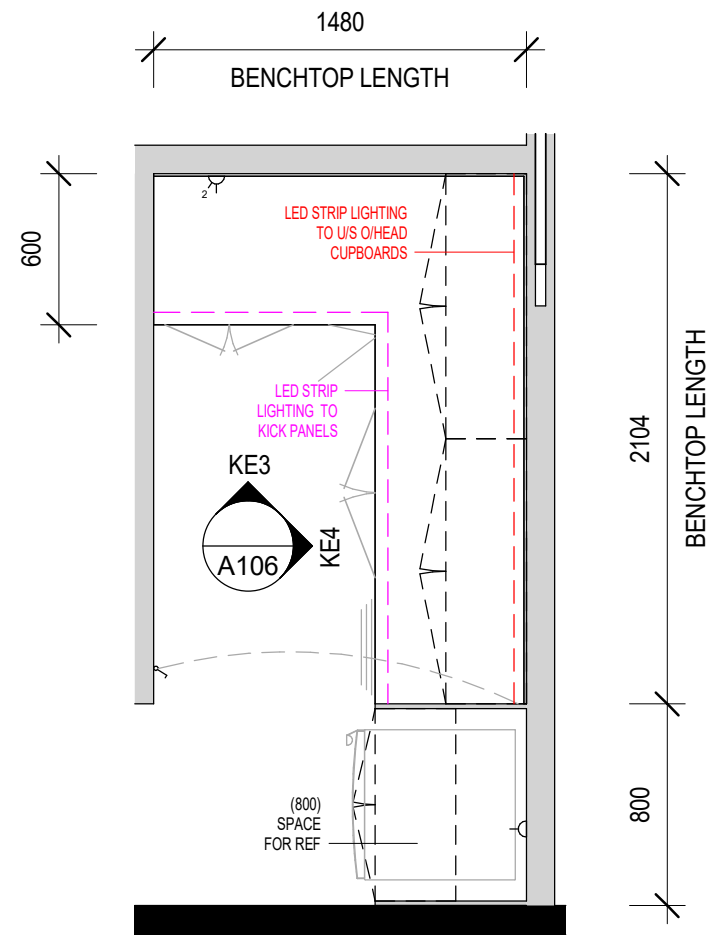


KITCHEN PART B - PLAN VIEW

1 : 30

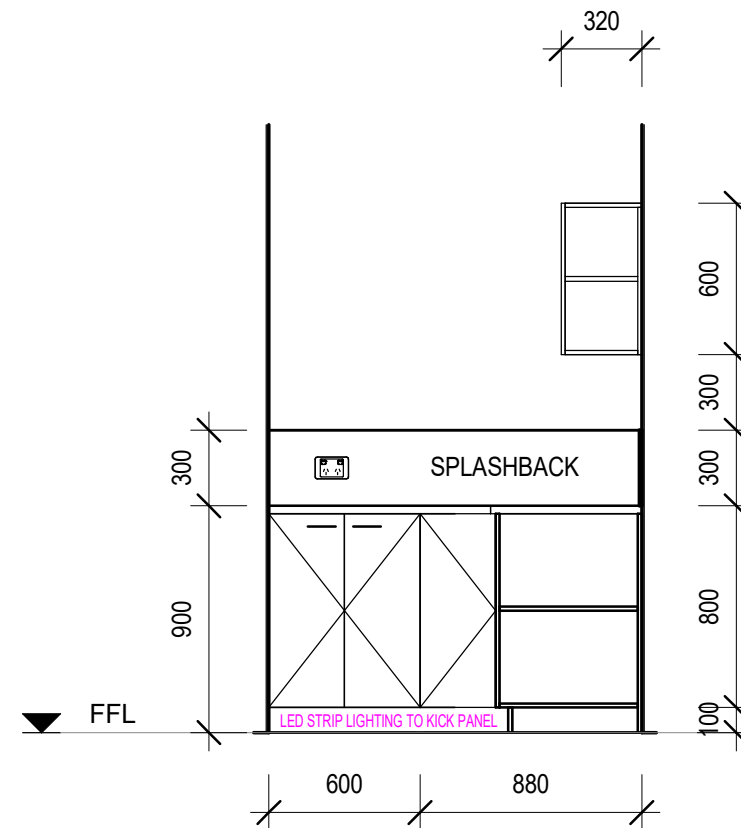

KITCHEN ELEVATION 3 (KE3)

1 : 30

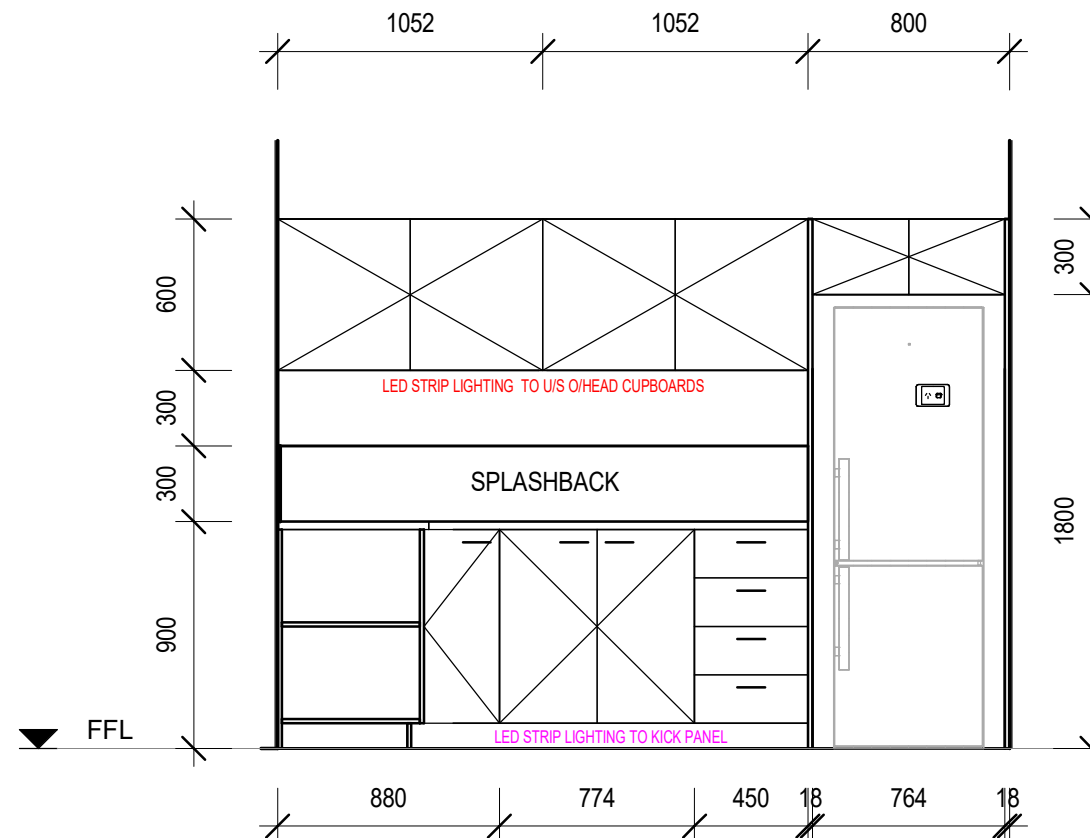

KITCHEN ELEVATION 4 (KE4)

1 : 30

SET OUTS, LEVELS AND CRITICAL DIMENSIONS TO BE
CONFIRMED ON SITE PRIOR TO FABRICATION
DO NOT SCALE FROM THIS DRAWING, USE FIGURED
DIMENSIONS
ALL CONSTRUCTION TO COMPLY WITH NATIONAL
CONSTRUCTION CODE OF AUSTRALIA (NCC) AND
RELEVANT AUSTRALIAN STANDARDS
ALL DESIGNS © ORANA, 2026

REVISION SCHEDULE

REV	DESCRIPTION	DATE	BY
A	ISSUED FOR REVIEW	28.03.26	DM

DRAWING STATUS

ISSUED FOR
REVIEW

ORANA

14729 Spring Avenue,
Santa Fe Springs, CA, 90670
E: hello@oranausa.com
P: 888 256 6416

BUILDING NAME

'THE BREEZE'

DESCRIPTION

3 BEDROOM DWELLING
WITH BREEZEWAY

CLIENT

ORANA

SHEET TITLE

KITCHEN JOINERY
DETAILS (PART B)

DRAWING NUMBER

A106

REVISION
A
SCALE AT A3
1 : 30

29/03/2026 3:08:55 AM

SET OUTS, LEVELS AND CRITICAL DIMENSIONS TO BE
CONFIRMED ON SITE PRIOR TO FABRICATION
DO NOT SCALE FROM THIS DRAWING, USE FIGURED
DIMENSIONS
ALL CONSTRUCTION TO COMPLY WITH NATIONAL
CONSTRUCTION CODE OF AUSTRALIA (NCC) AND
RELEVANT AUSTRALIAN STANDARDS
ALL DESIGNS © ORANA, 2026

REVISION SCHEDULE			
REV	DESCRIPTION	DATE	BY
A	ISSUED FOR REVIEW	28.03.26	DM

DRAWING STATUS

ISSUED FOR
REVIEW

ORANA

14729 Spring Avenue,
Santa Fe Springs, CA, 90670
E: hello@oranausa.com
P: 888 256 6416

BUILDING NAME

'THE BREEZE'

DESCRIPTION

3 BEDROOM DWELLING
WITH BREEZEWAY

CLIENT

ORANA

SHEET TITLE


LAUNDRY JOINERY
DETAILS

DRAWING NUMBER

A107


REVISION
A
SCALE AT A3
1 : 30

29/03/2026 3:08:56 AM

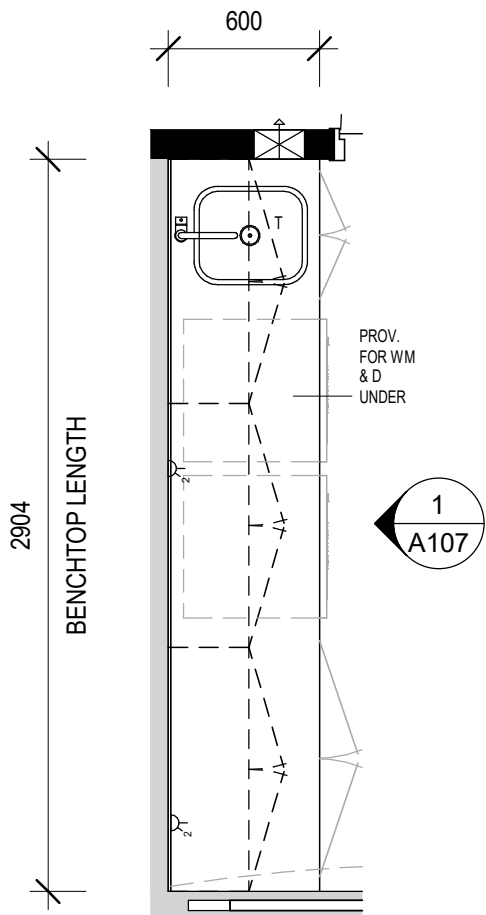

LAUNDRY - PLAN VIEW

1 : 30

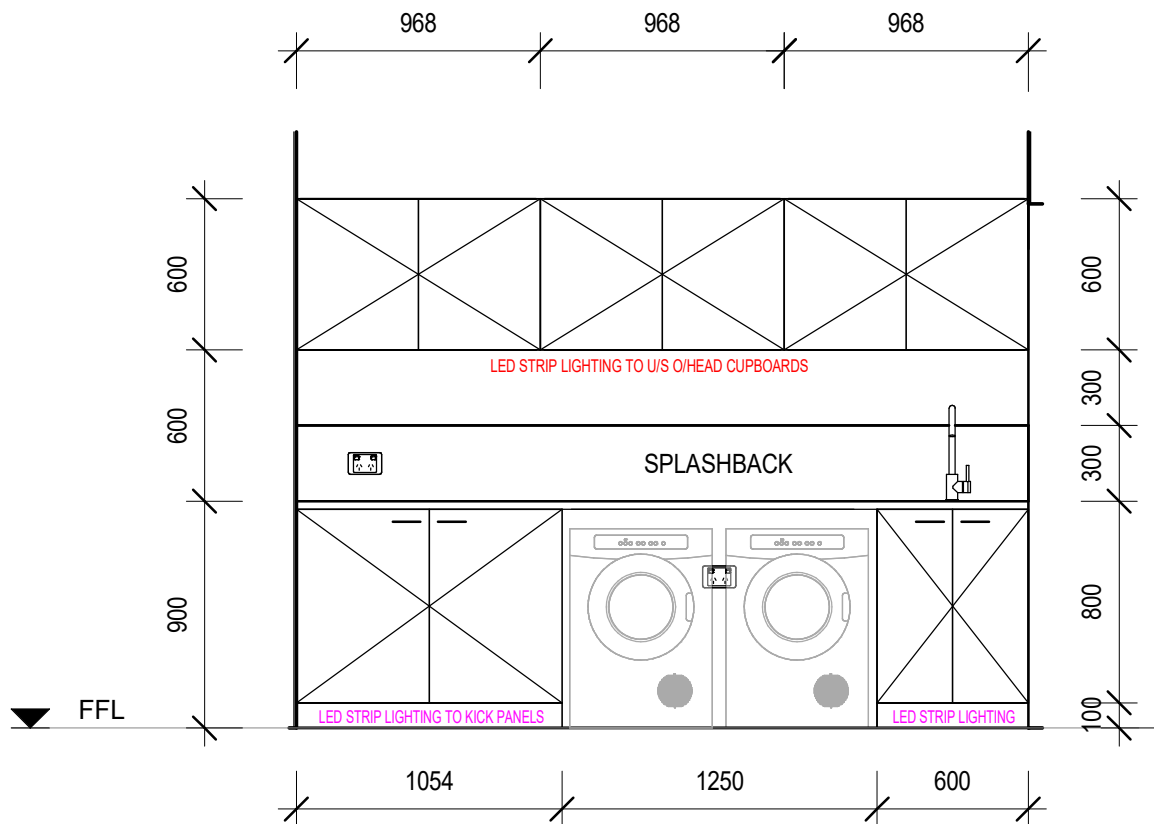

LAUNDRY ELEVATION (LE)

1 : 30

SUB-FLOOR SYSTEM

SKID BEAMS: < W10x22 STEEL SKID BEAM SYSTEM

FLOOR SYSTEM

FLOOR FRAMING: 100 x 1.5mm LIPPED CHANNEL JOISTS @ 450mm CS
INSULATION - U/FLOOR: R15 (OR EQUIV.) MINIMUM INSULATION VALUE
FLOORING 3/4" STRUCTURAL PLYWOOD
FLOOR COVERING: SPC PLANKS (STONE PLASTIC COMPOSITE CORE)
DECKING COMPOSITE TIMBER DECKING

WALL SYSTEM

FRAMING: 92mm (OR EQUIV.) ENGINEERED STEEL FRAME

INSULATION: R15 (OR EQUIV.) MINIMUM INSULATION VALUE TO INTERNAL AND EXTERNAL WALLS

CLADDING: CHOICE OF THE FOLLOWING THEMES -
'MODERN'
'CONTEMPORARY'
'HAMPTONS'
'TRADITIONAL'

INTERNAL: 5/8" DRYWALL, SET & PAINTED

BATHROOM: LINED WITH SPC SHEETS

ROOF SYSTEM

ROOF SYSTEM: ENGINEERED STEEL FRAME/ RAFTER SYSTEM
INSULATION: R19 (OR EQUIV.) BATTS + R9 (OR EQUIV.) BLANKET OVER. TOTAL MINIMUM INSULATION VALUE = R26
STEEL PANEL ROOFING
INTERNAL: 5/8" DRYWALL, SET & PAINTED (SQUARE SET)

FINISHES SCHEDULE

ITEM	COLOUR	
FLOOR COVERING:		
SPC PLANKS	'TBC'	(GENERALLY)
FLOOR TILES	'TBC'	(BATHROOM)
CARPET	'TBC'	(BEDROOMS)
CLADDING:		
CORNER ANGLES	'TBC'	
INTERNAL FEATURE WALLS		
LIVING AREA	'TBC'	
BEDROOMS	'TBC'	
BATHROOM WALLS	'TBC'	
WALLS, GENERALLY		
CEILING	'BRIGHT WHITE' MATTE	(STANDARD)
	'BRIGHT WHITE' MATTE	(STANDARD)
ROOF:		
ROOF SHEET	'SHALE GREY'	
GUTTER	NIL - N/A	
FASCIA	'TBC'	
EXTERNAL DOOR:		
SLIDING GLASS DOORS	'TBC'	(uPVC)
SWING DOOR FRAME	'TBC'	(TIMBER)
DOOR BLANK	'N/A'	
WINDOWS		
WINDOW FRAMES	'TBC'	(uPVC)

DOOR SCHEDULE									
No.	DOOR LEAF			DOOR FRAME	DOOR HARDWARE			QTY	COMMENTS
	DOOR LEAF	SIZE		FRAME	HANDLE TYPE	LOCKSET	CLOSER		
		H	W						
D1a	SLIDING GLASS DOOR	2100	2400	uPVC	'D'	ENTRANCE	No	1	
D1b	SLIDING GLASS DOOR	2100	2400	uPVC	'D'	ENTRANCE	No	1	
D2	SOLID CORE	2040	820	TIMBER	KNOB	ENTRANCE	No	1	/W GLASS PANELS
D3	HOLLOW CORE	2040	720	TIMBER	CAV	PASSAGE	No	5	CAVITY SLIDER
D4	HOLLOW CORE	2040	720	TIMBER	CAV	PRIVACY	No	2	CAVITY SLIDER

WINDOW SCHEDULE									
No.	TYPE	GLAZING	SIZE		SILL HEIGHT	FRAME	SECURITY	QTY	COMMENTS
			H	W					
W1	SLIDING	OBSCURE GLASS	600	600	1500	uPVC	-	1	
W2	SLIDING	CLEAR GLASS	600	1800	1500	uPVC	-	5	
W3	TRANSOM	CLEAR GLASS	2100	600	0	uPVC		7	

MECHANICAL SERVICES SCHEDULE			
No.	DESCRIPTION	QTY	COMMENTS
-	2 IN 1 EXHAUST FAN AND LIGHT COMBO	1	CEILING MOUNTED
AC1	2.6kW SPLIT SYSTEM AC UNIT	2	CONDENSING UNITS INSTALLED ON SITE
EXF	EXHAUST FAN, WALL MOUNTED	1	
RH	UNDERMOUNT RANGHOOD, 60cm	1	

FITTINGS SCHEDULE		
ITEM	DESCRIPTION	QTY
Electrical Fixtures		
-	GPO, 1x10A	2
-	GPO, 2x10A	13
-	ISOLATION SWITCH 1x20A FOR AIR CONDITIONER (WP)	2
-	SMOKE DETECTOR 120V, HARDWIRED WITH BATTERY BACKUP	3
DSB	SWITCHBOARD & ELEC. POINT OF ENTRY	2
Lighting Fixtures		
-	DOWNLIGHT - LED	23
-	KITCHEN FEATURE HANGING PENDANT LIGHT	1
-	LIGHT SWITCH, 3 GANG	1
-	LIGHT SWITCH, DOUBLE WITH SWITCH FOR KITCHEN PENDANT & STRIP LIGHTING	1
-	LIGHT SWITCH, DOUBLE WITH SWITCH FOR LAUNDRY STRIP LIGHTING	1
-	LIGHT SWITCH, SINGLE	6
-	SWITCH FOR 2-IN-1 EXH FAN/LIGHT COMBO	1
Plumbing Fixtures		
-	LAUNDRY MIXER TAP	1

FITTINGS SCHEDULE		
ITEM	DESCRIPTION	QTY
-	RAIL SHOWER WITH HEAD AND WAND	1
-	SHOWER MIXER TAP	1
fw	FLOOR WASTE	1
SHW1	SEMI-FRAMELESS GLASS SHOWER SCREEN, NO DOOR, 1700x900mm	1
SK	SINK, 1 BOWL, 1 DRAIN - 780mm LONG	1
T	COMPACT LAUNDRY TUB, 35L	1
VB1	VANITY, 2 DOOR, 2 DRAWER - 900W x 460D (TEAK OAK FINISH)	1
WC	WC SUITE, RIMLESS, B2W, (CERAMIC BOWL)	1
Specialty Equipment		
CT	60cm ELECTRIC COOKTOP	1
D	PROVISION FOR DRYER	1
DW	PROVISION FOR DISHWASHER	1
MIR	WALL MOUNTED LED MIRROR	1
OV	60cm ELECTRIC BUILT-IN OVEN	1
REF	PROVISION FOR FRIDGE	1
TR	TOWEL RAIL, 600mm LONG	1
TRH	TOILET ROLL HOLDER	1
WM	PROVISION FOR WASHING MACHINE	1

INCLUSIONS ARE INDICATIVE ONLY, TO BE DISCUSSED
TAPWARE FOR SINK, VANITIES, TOWEL RAIL, TOILET ROLL HOLDER, SHOWER HEAD AND RAIL - GRAPHITE (STANDARD)
KITCHEN SINK - GRAPHITE (STANDARD)

SET OUTS, LEVELS AND CRITICAL DIMENSIONS TO BE
CONFIRMED ON SITE PRIOR TO FABRICATION
DO NOT SCALE FROM THIS DRAWING, USE FIGURED
DIMENSIONS
ALL CONSTRUCTION TO COMPLY WITH NATIONAL
CONSTRUCTION CODE OF AUSTRALIA (NCC) AND
RELEVANT AUSTRALIAN STANDARDS
ALL DESIGNS © ORANA, 2026

REVISION SCHEDULE			
REV	DESCRIPTION	DATE	BY
A	ISSUED FOR REVIEW	28.03.26	DM

DRAWING STATUS

ISSUED FOR
REVIEW

ORANA

14729 Spring Avenue,
Santa Fe Springs, CA, 90670
E: hello@oranausa.com
P: 888 256 6416

BUILDING NAME

'THE BREEZE'

DESCRIPTION

3 BEDROOM DWELLING
WITH BREEZEWAY

CLIENT

ORANA

SHEET TITLE

SCHEDULES

DRAWING NUMBER

A108

REVISION
A
SCALE AT A3

29/03/2026 3:08:57 AM

